



Note:
WALL THICKNESS = 230 mm

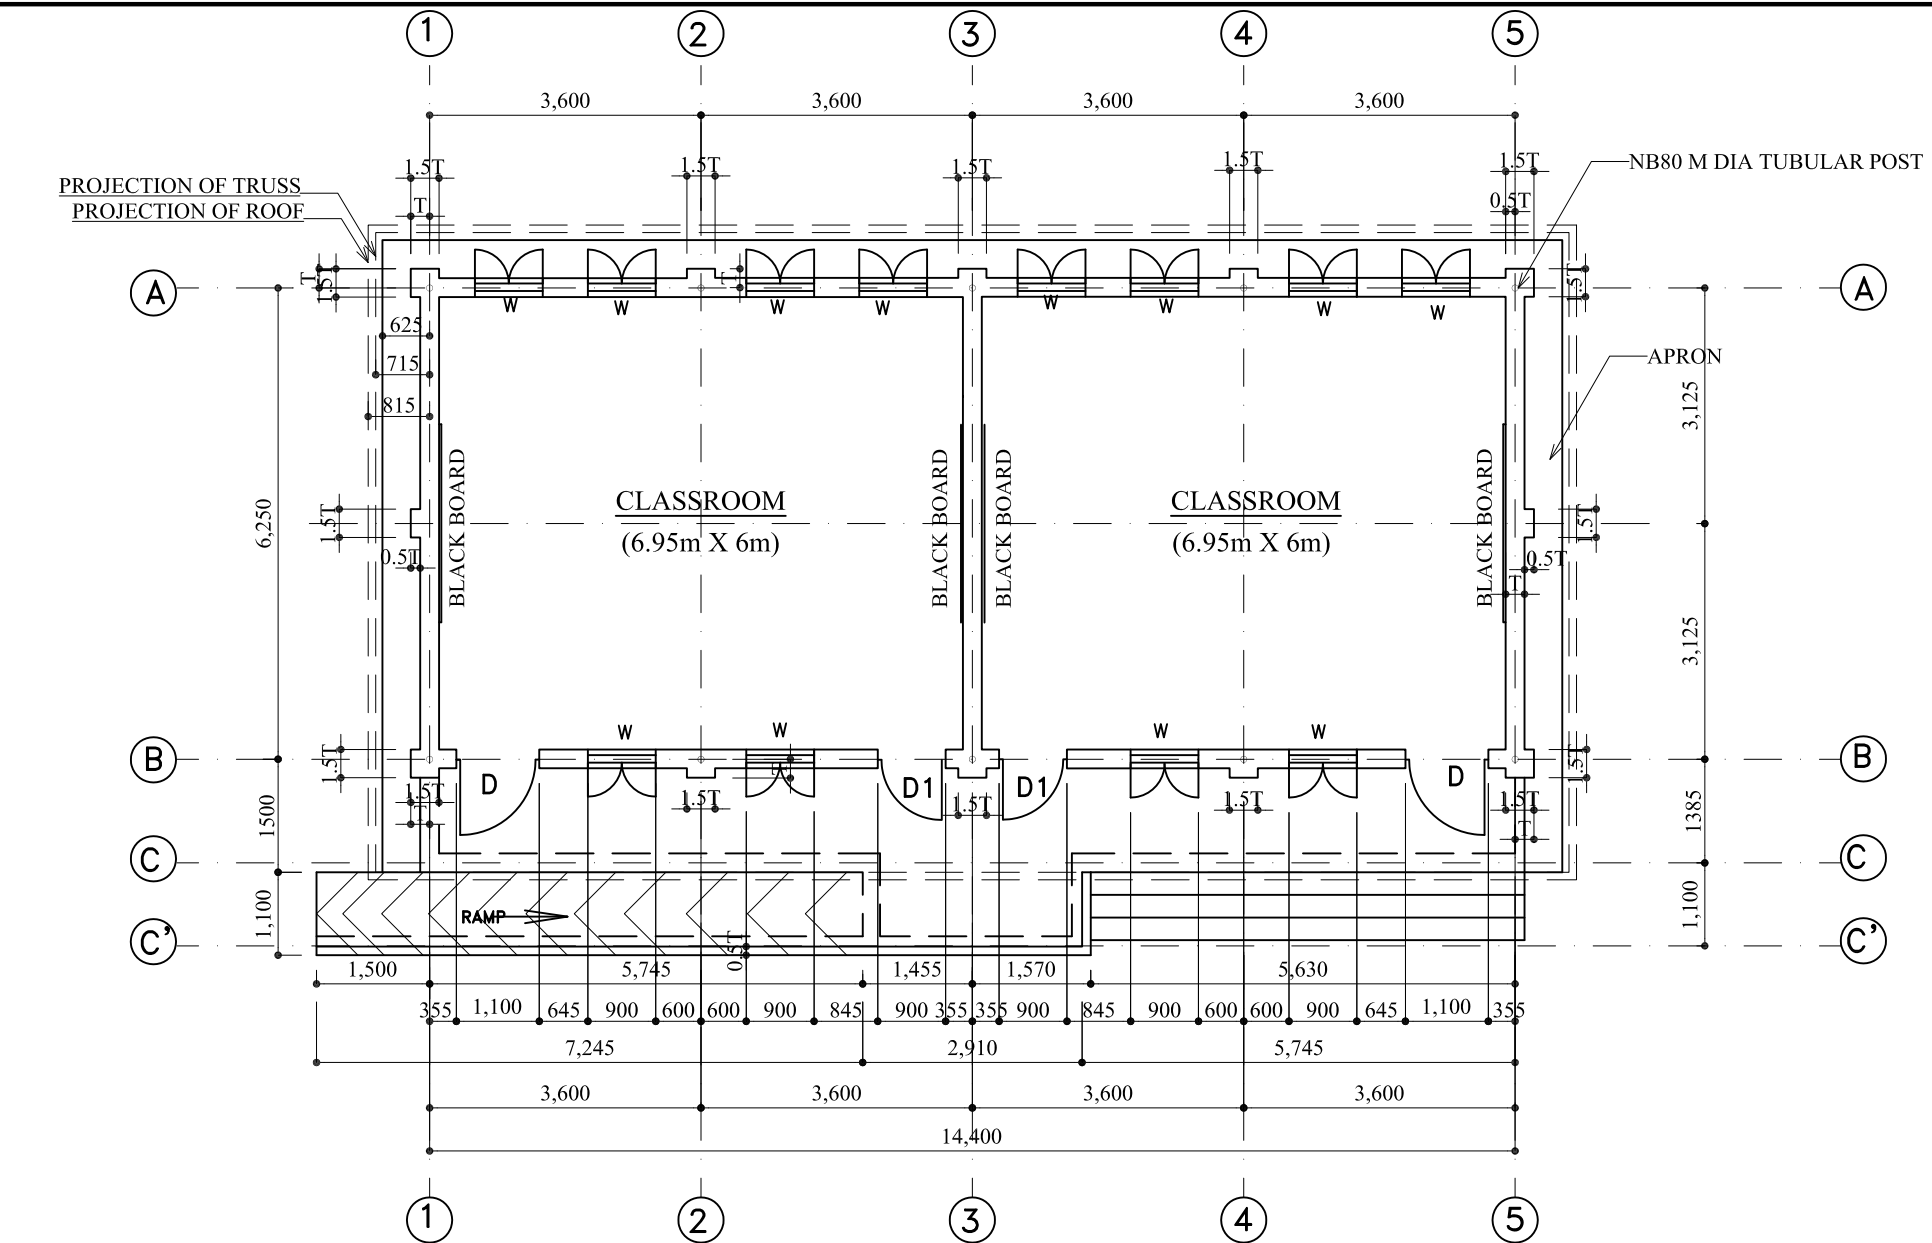


PLAN

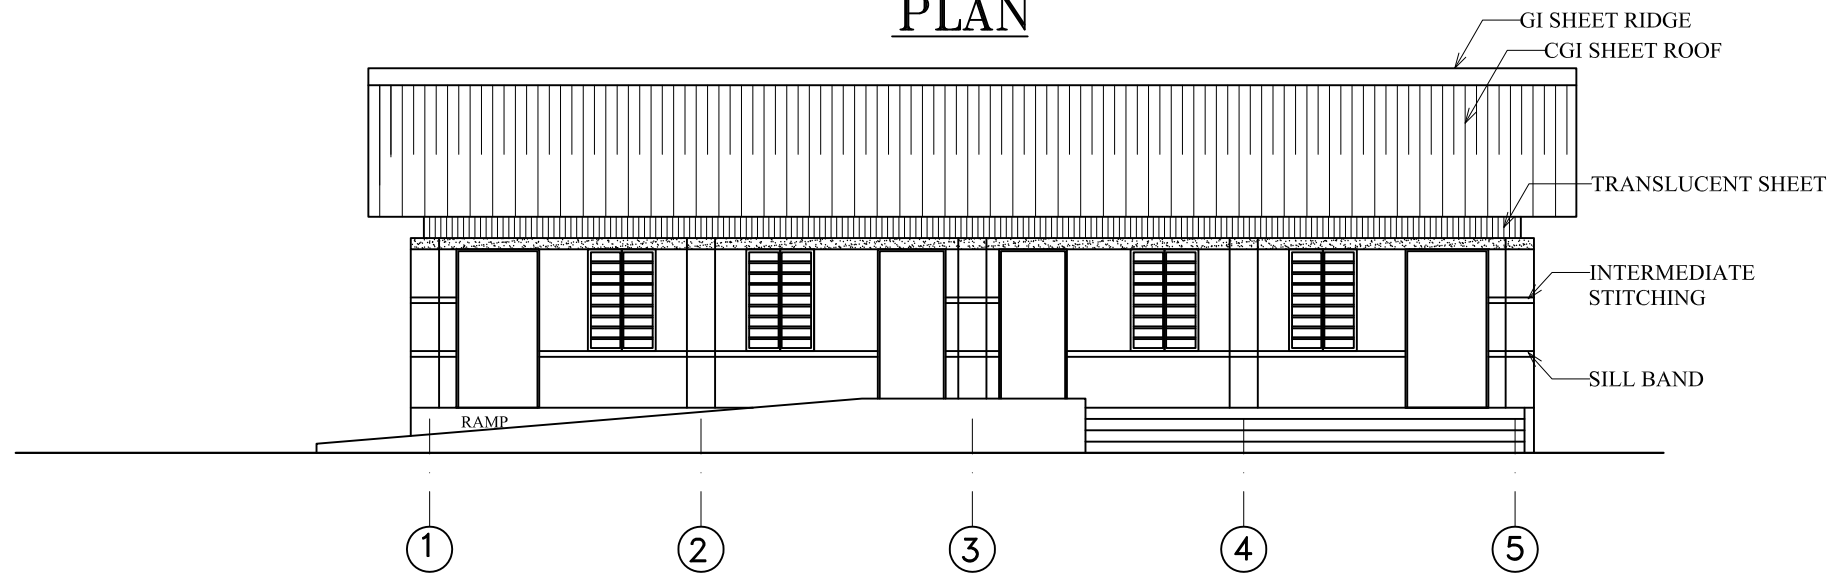


FRONT ELEVATION




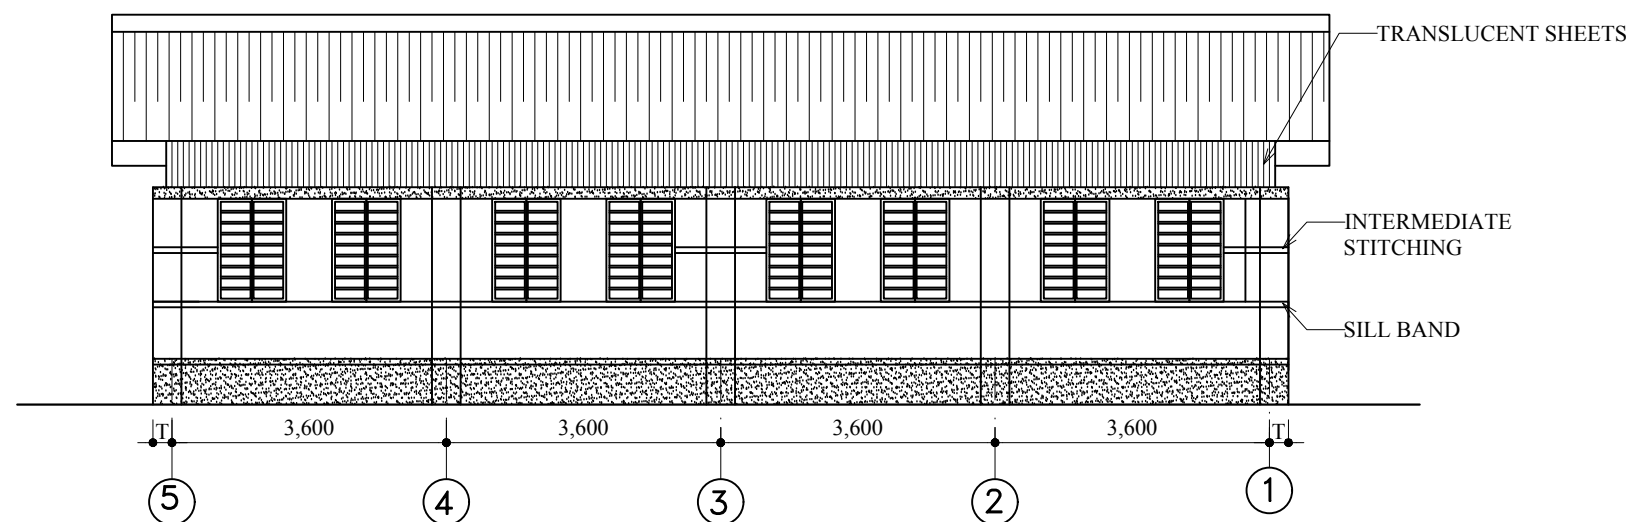

BACK ELEVATION

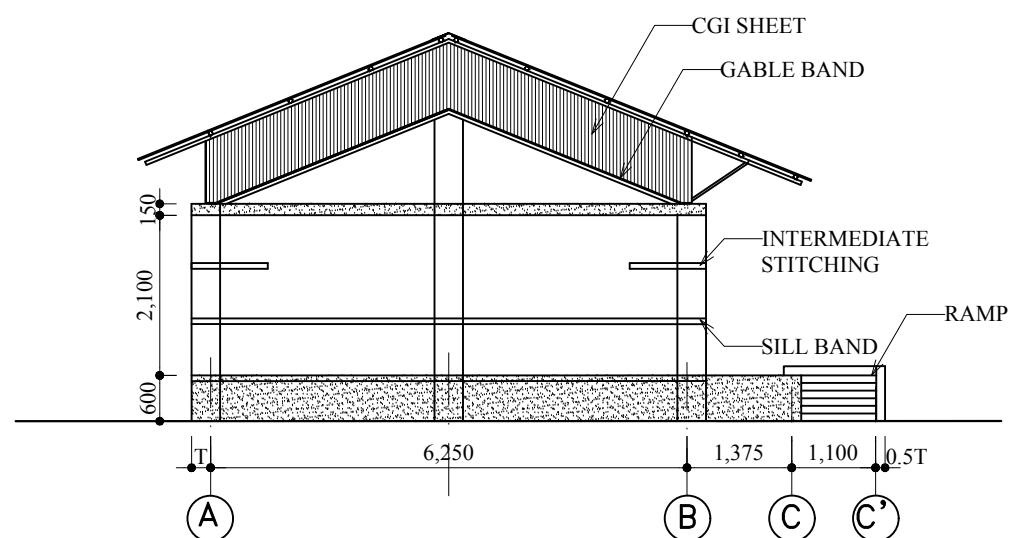


SIDE ELEVATION

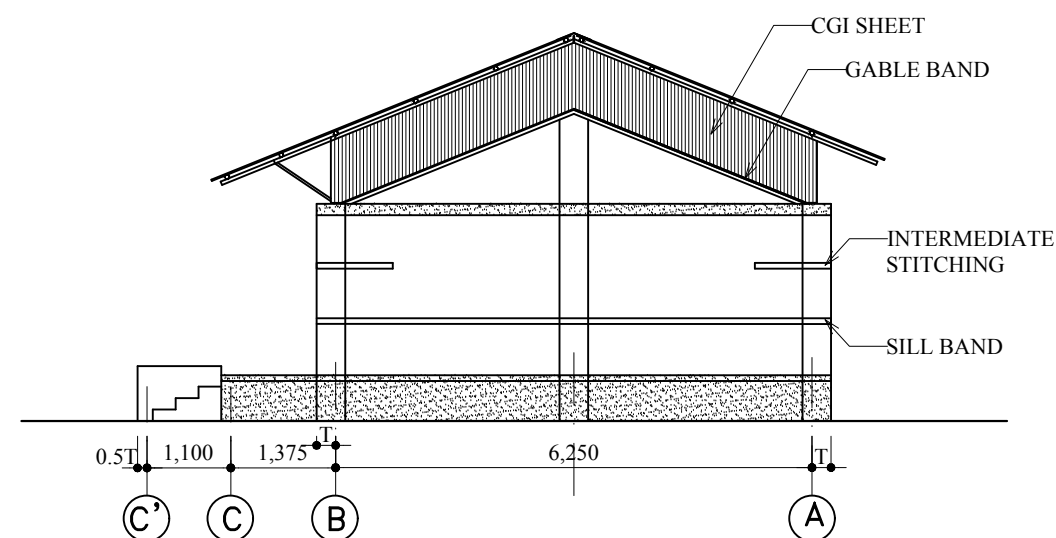



SIDE ELEVATION



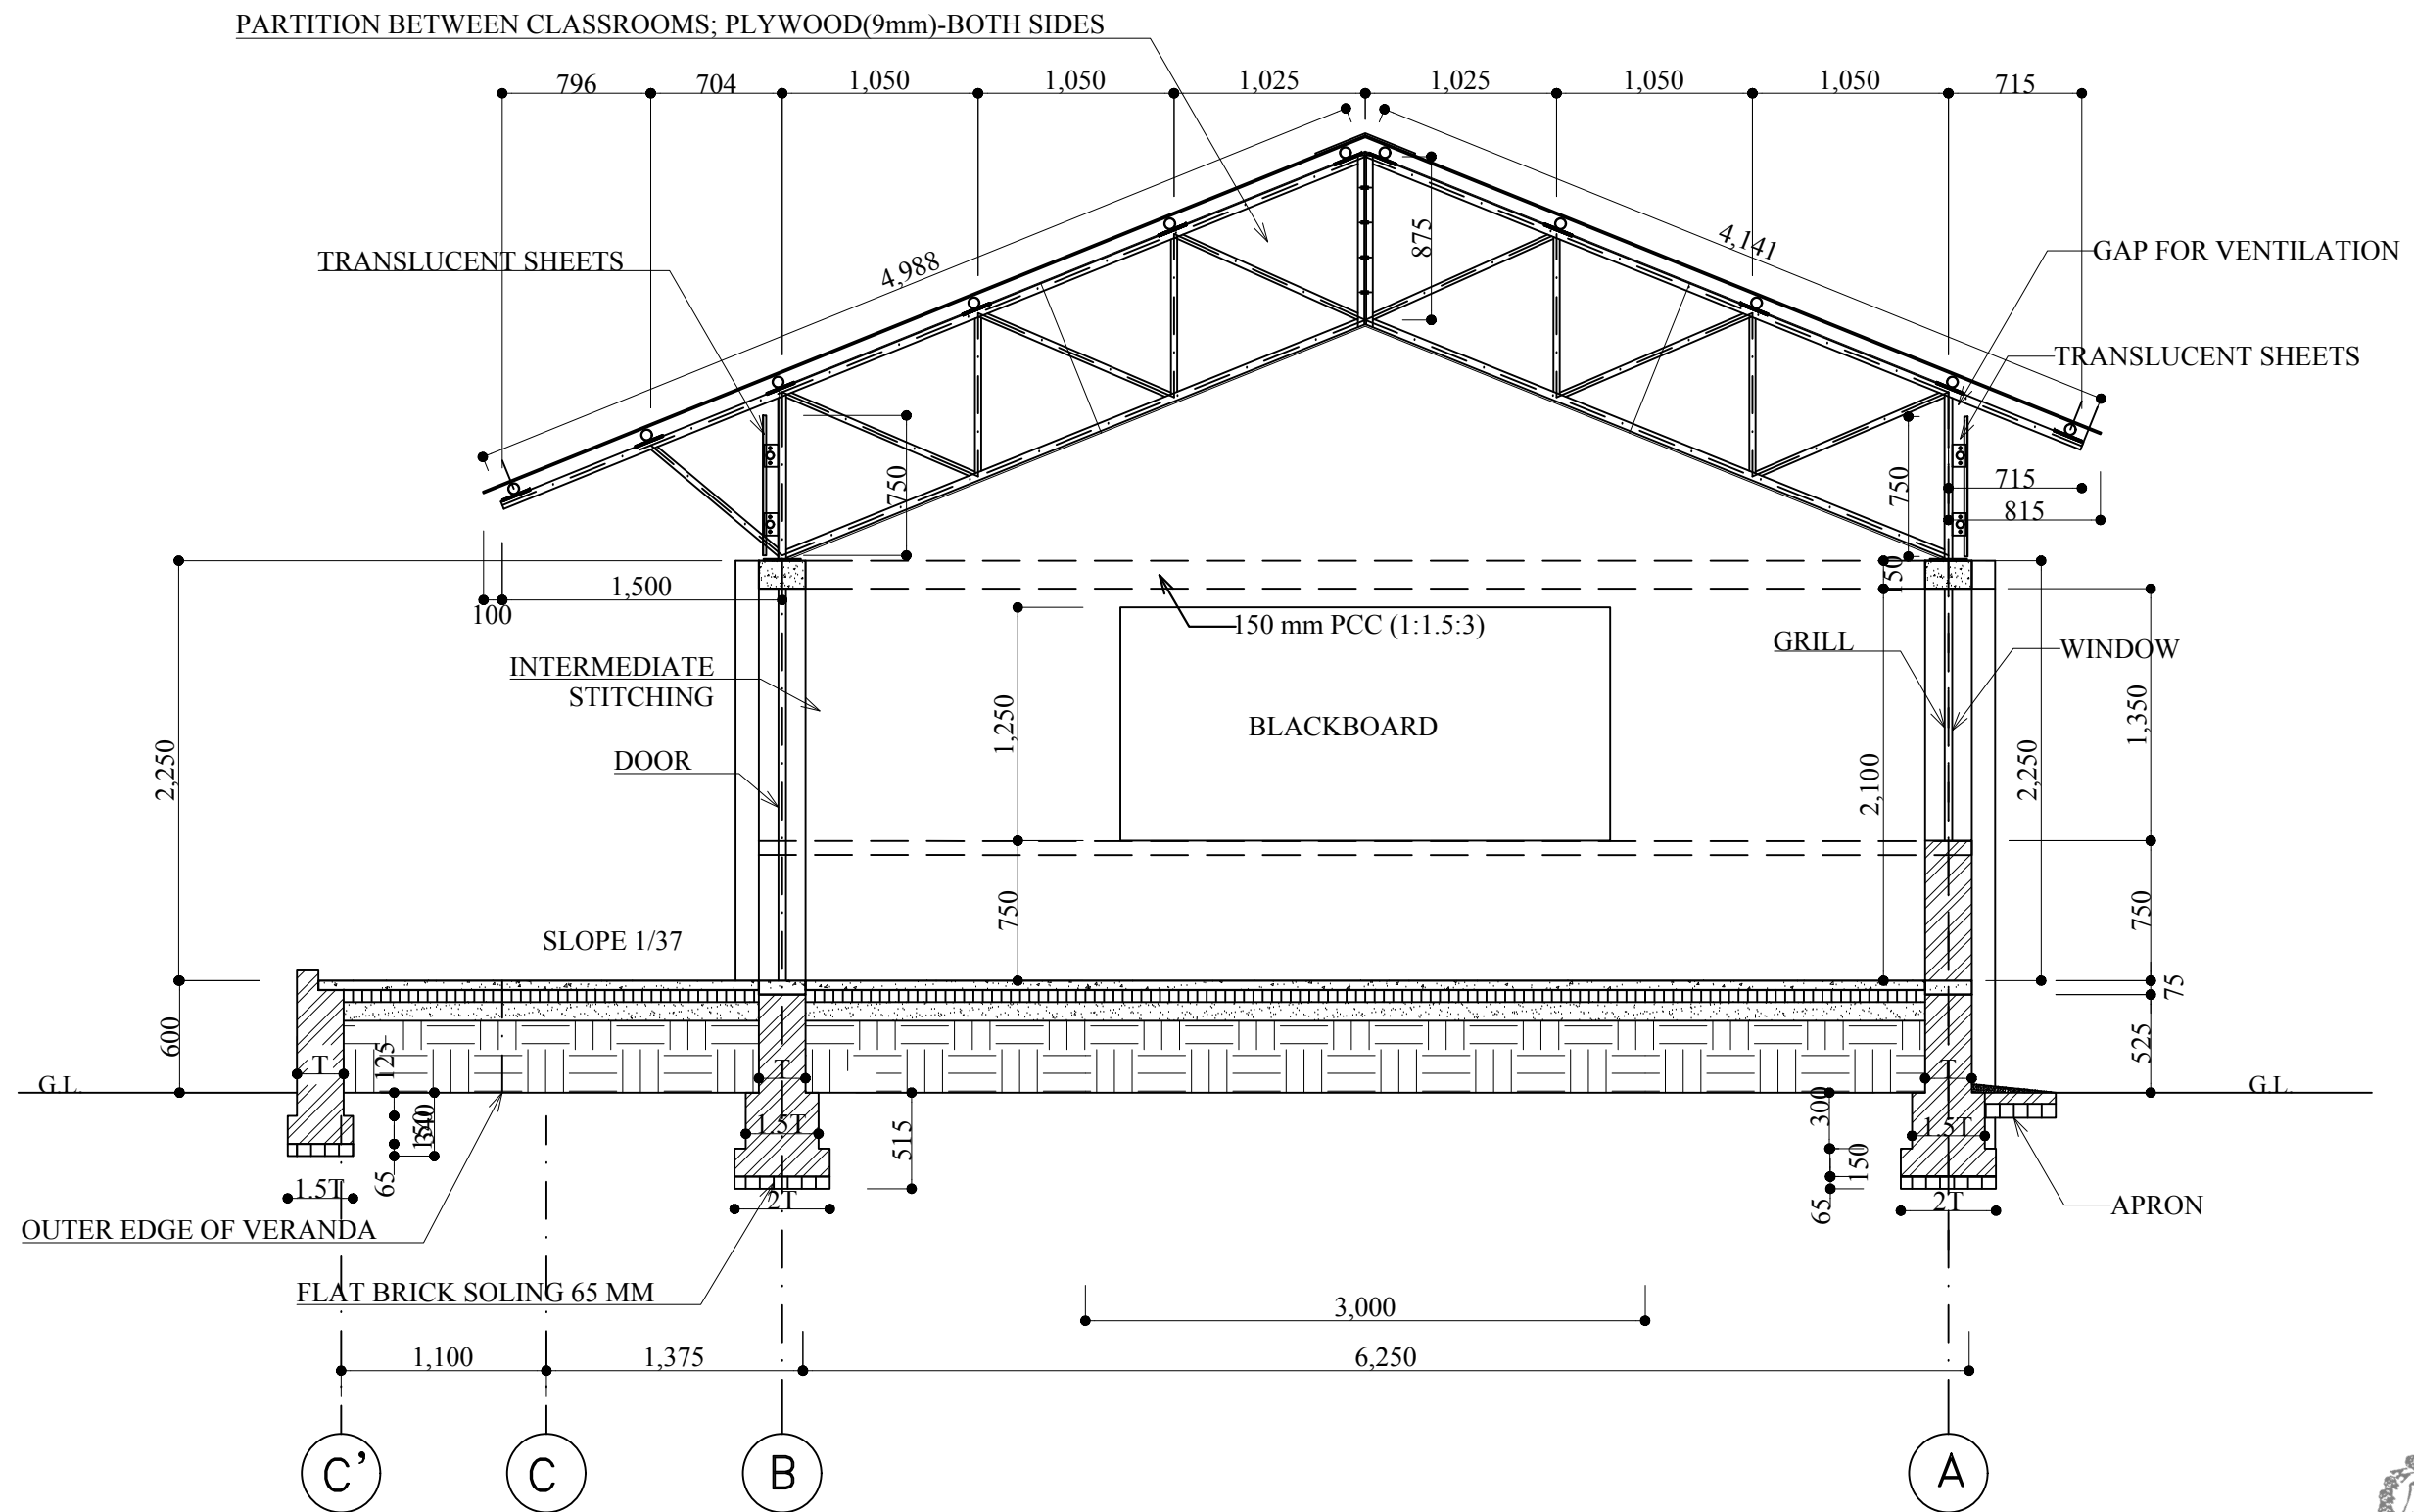


SECTION AT GRID 2-2, 4-4



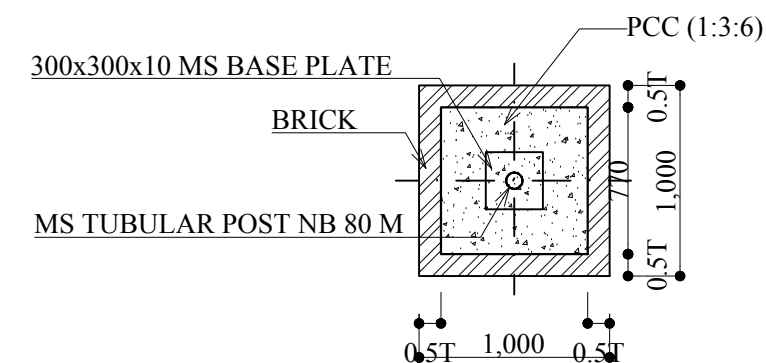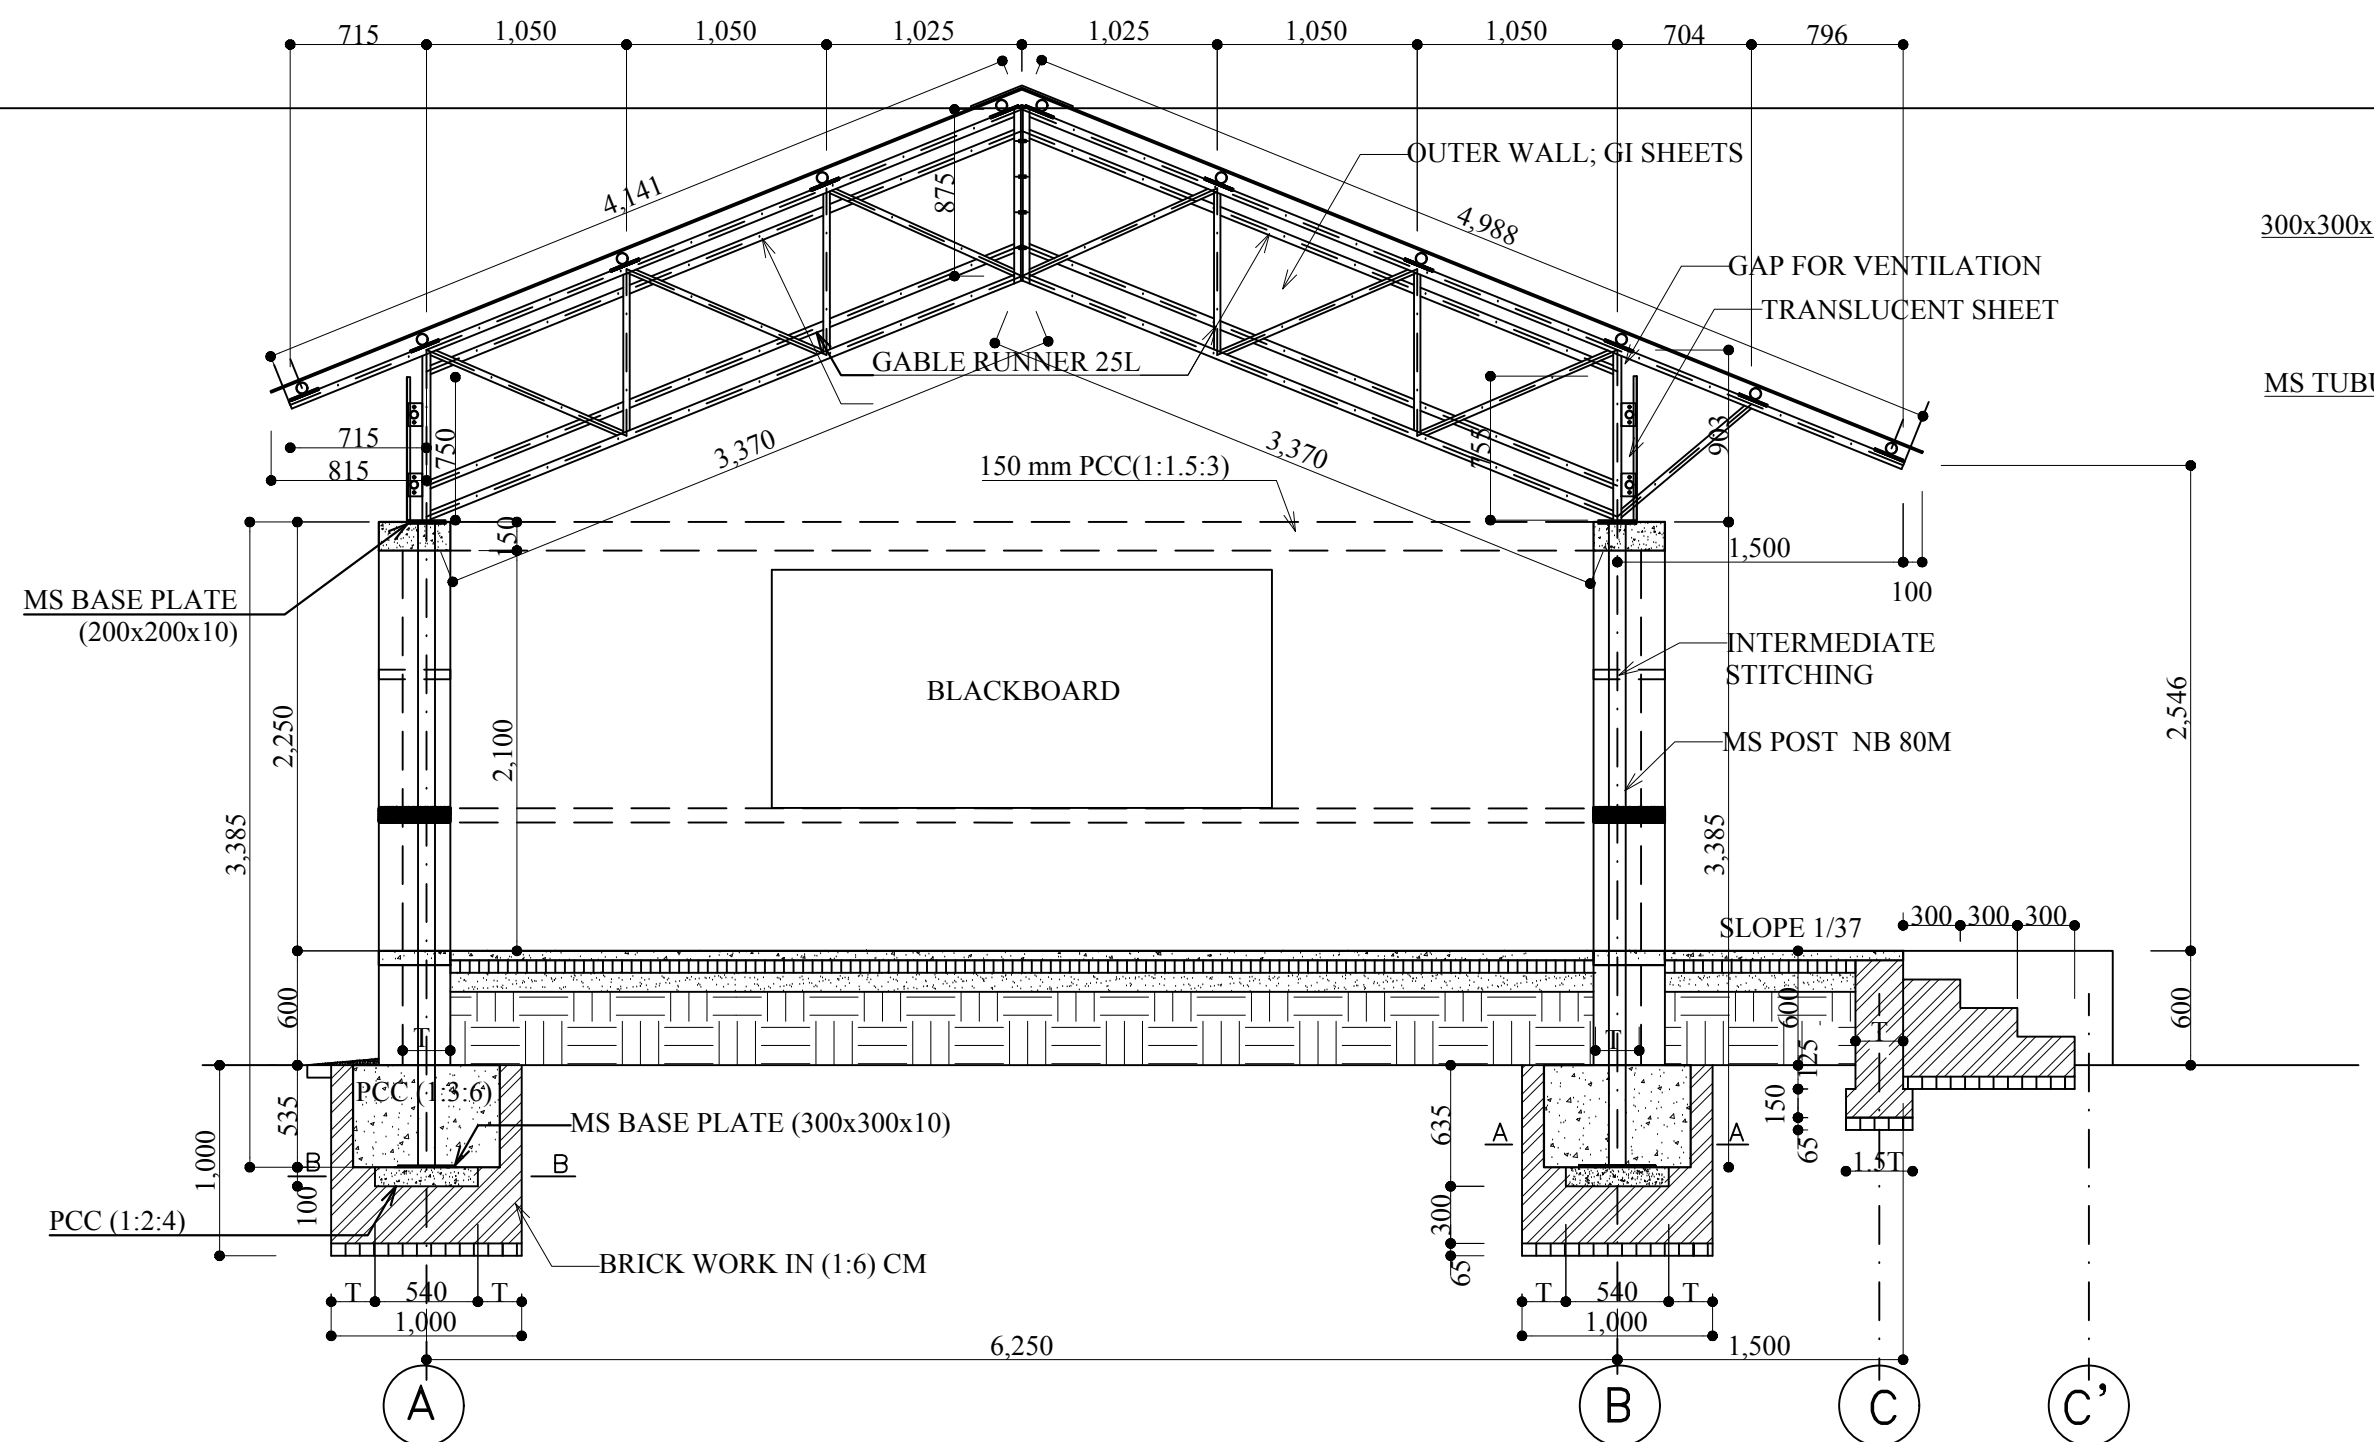


A-A

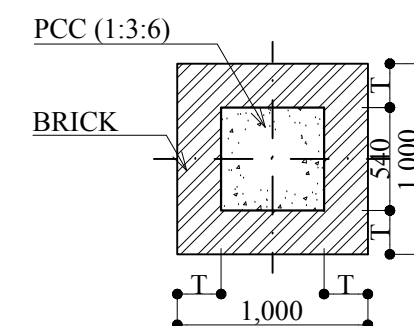

B-B


SECTION AT GRID 1-1, 3-3, 5-5



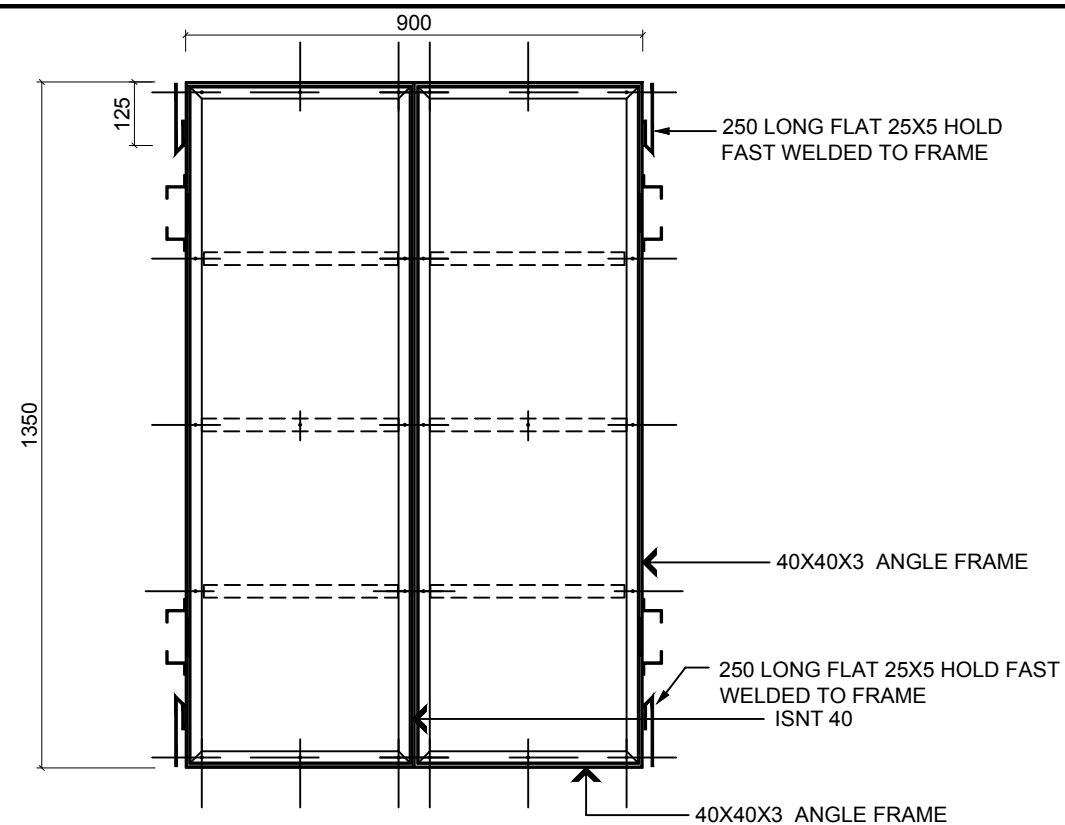


(FRAME ELEVATION LOOKING FROM OUTSIDE)


WINDOW (W)

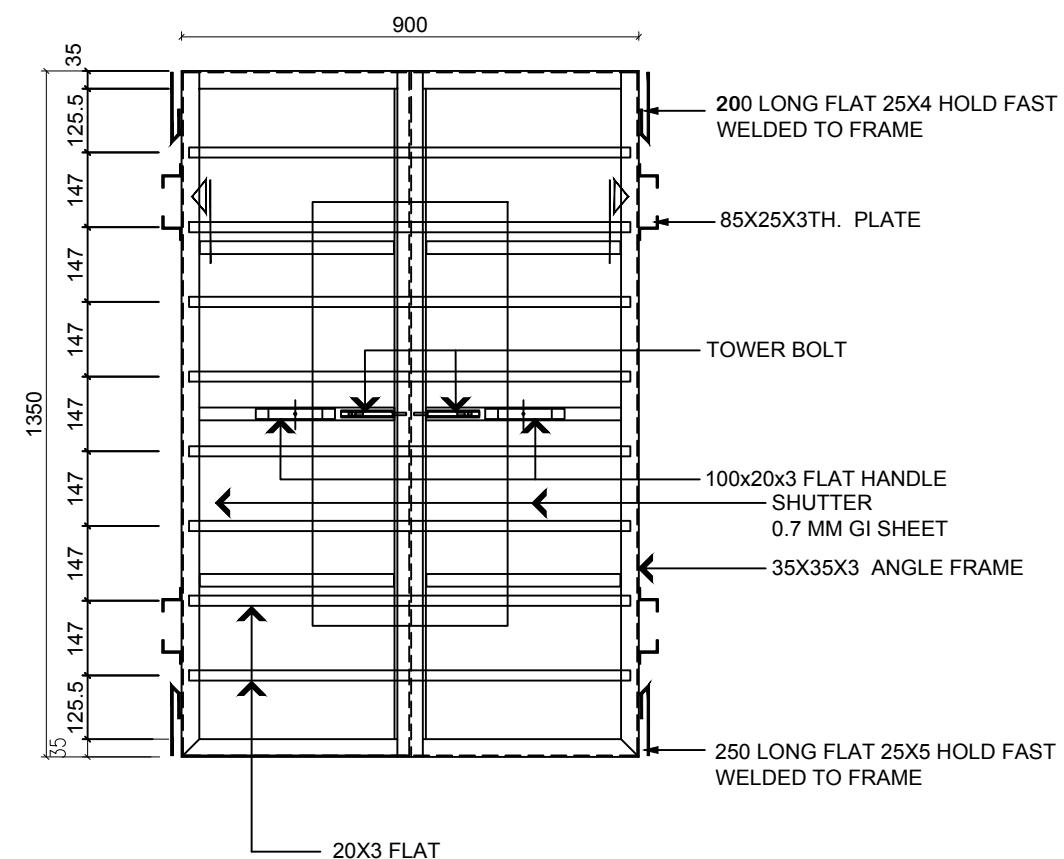


(FRAME ELEVATION LOOKING FROM INSIDE)

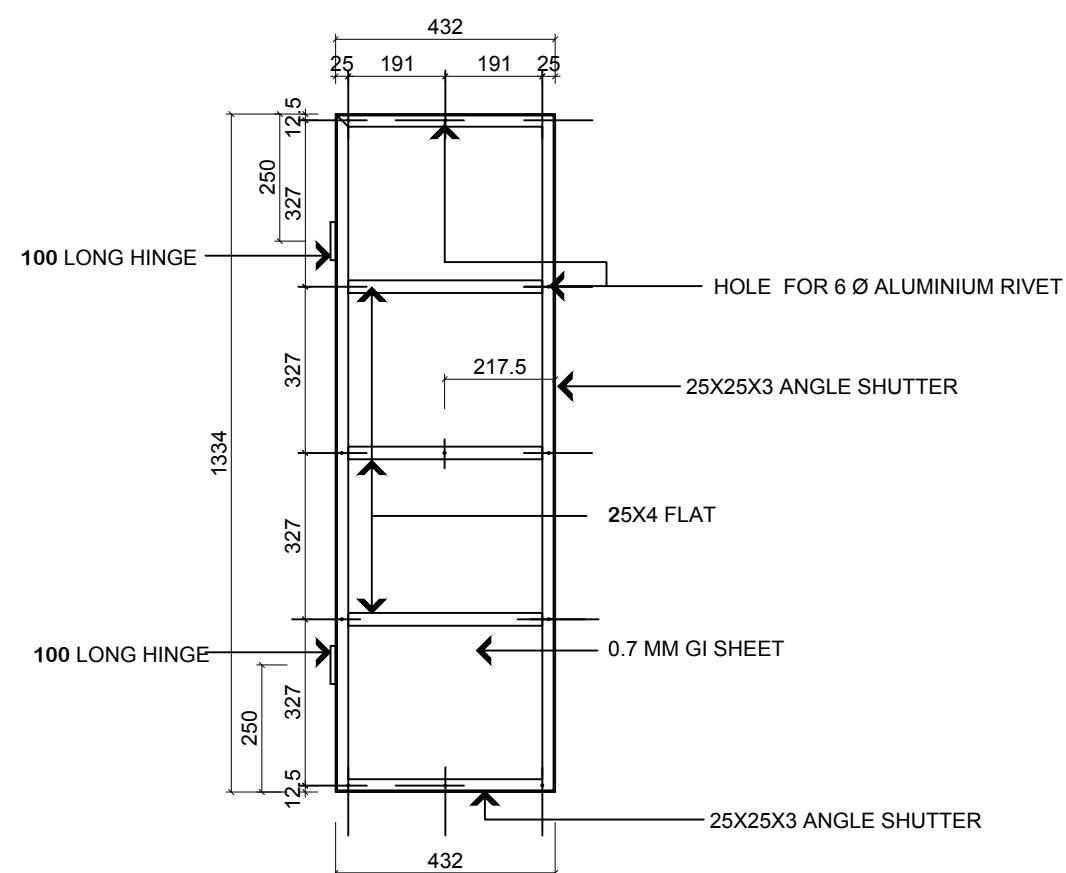


BACK VIEW OF WINDOW SHUTTER

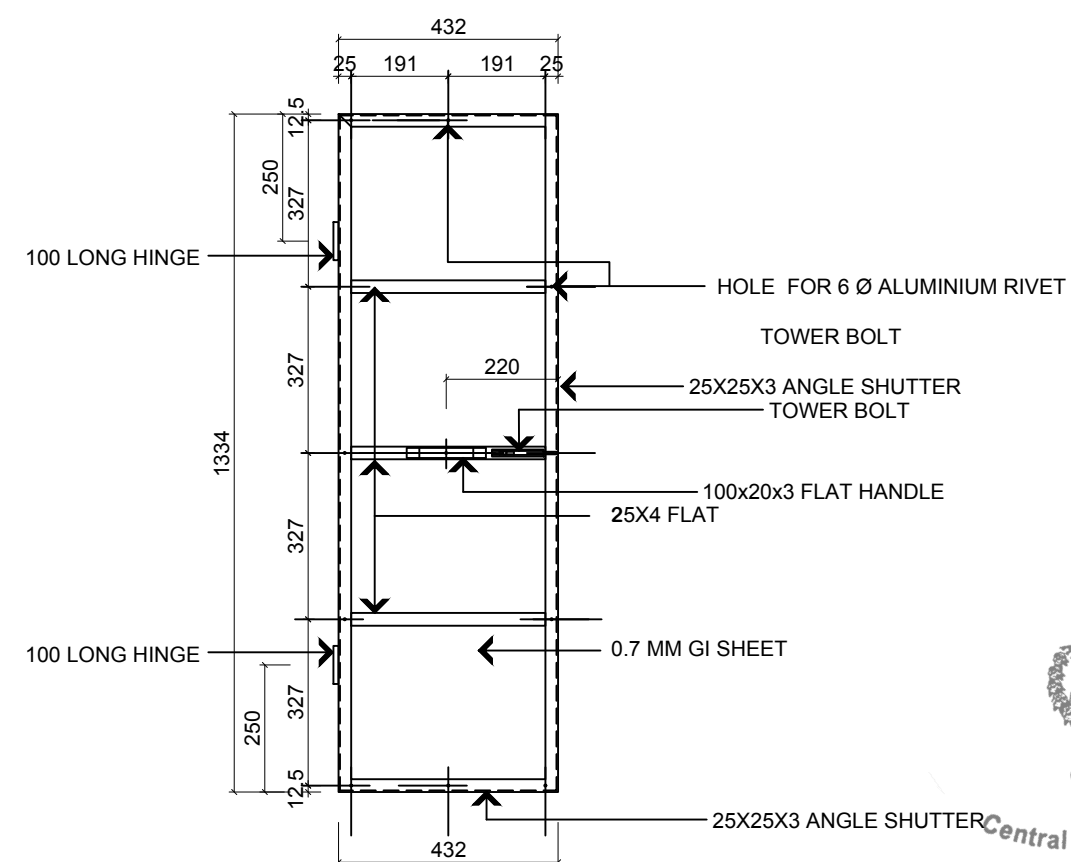

INSIDE VIEW OF WINDOW SHUTTER

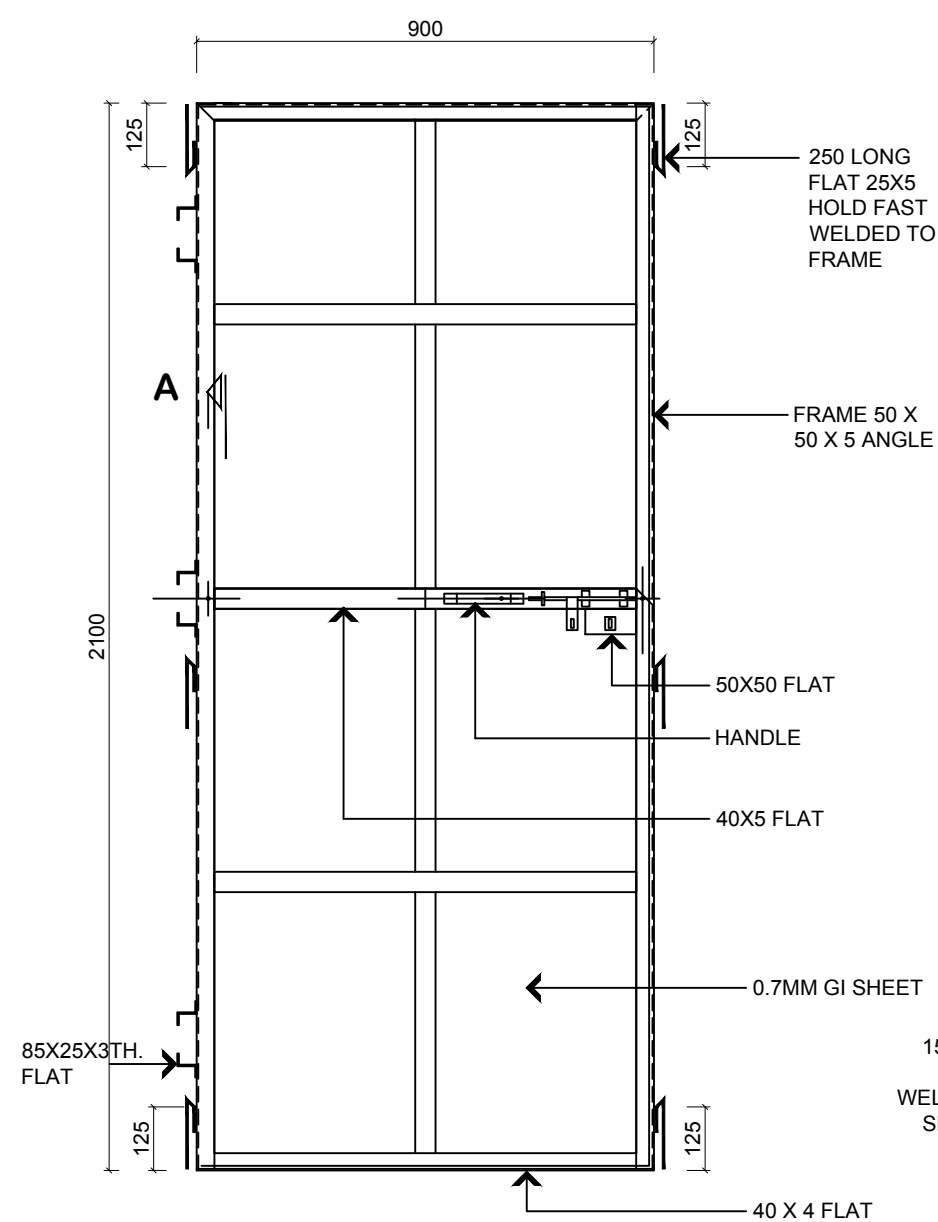


(FRAME ELEVATION LOOKING FROM
OUTSIDE)

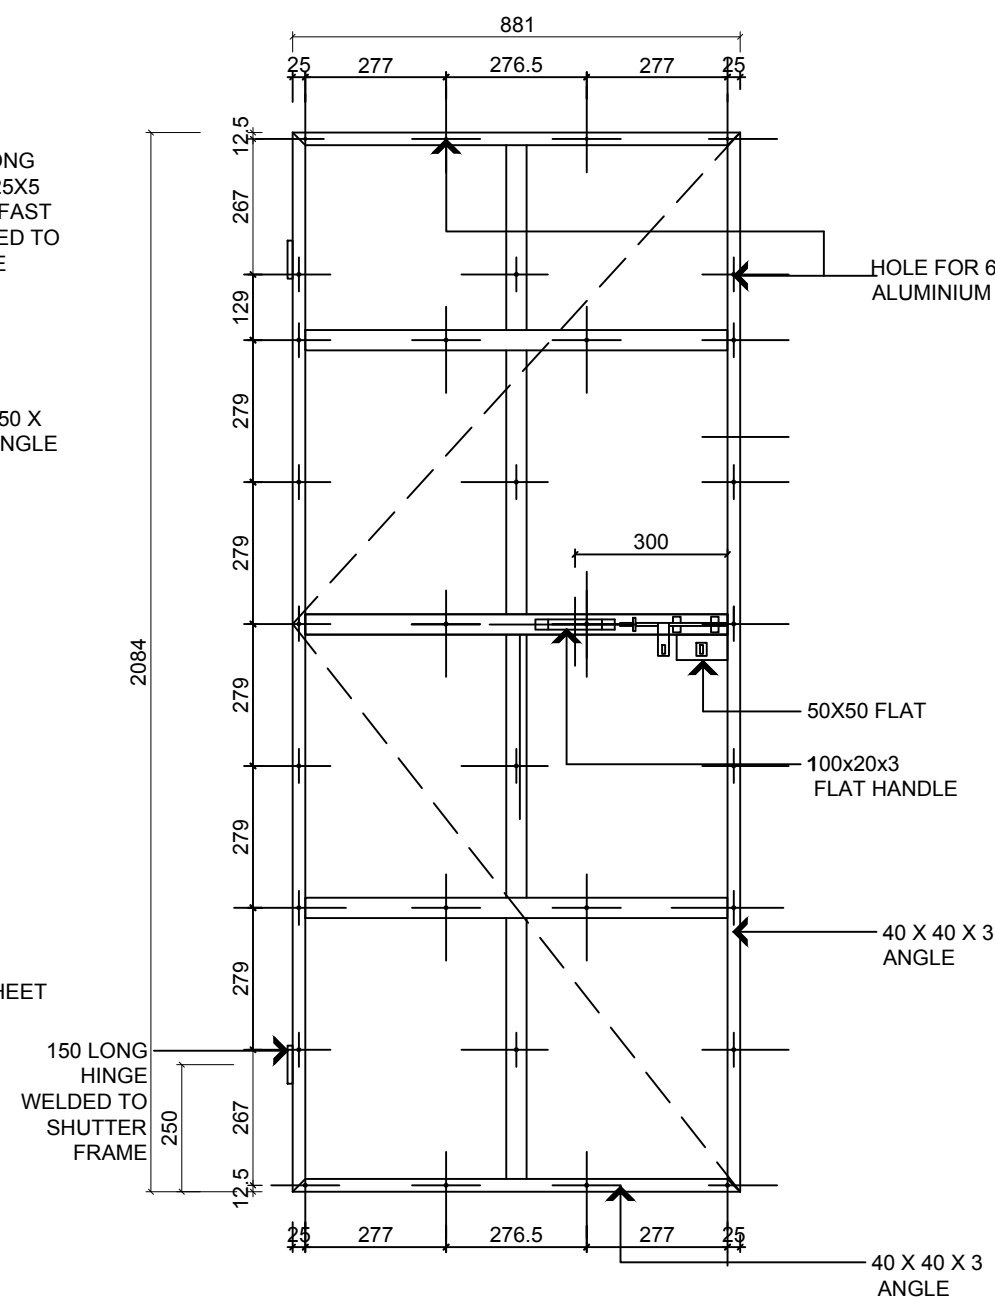


(LOOKING FROM OUTSIDE)
SHUTTER ELEVATION


DOOR (D1)

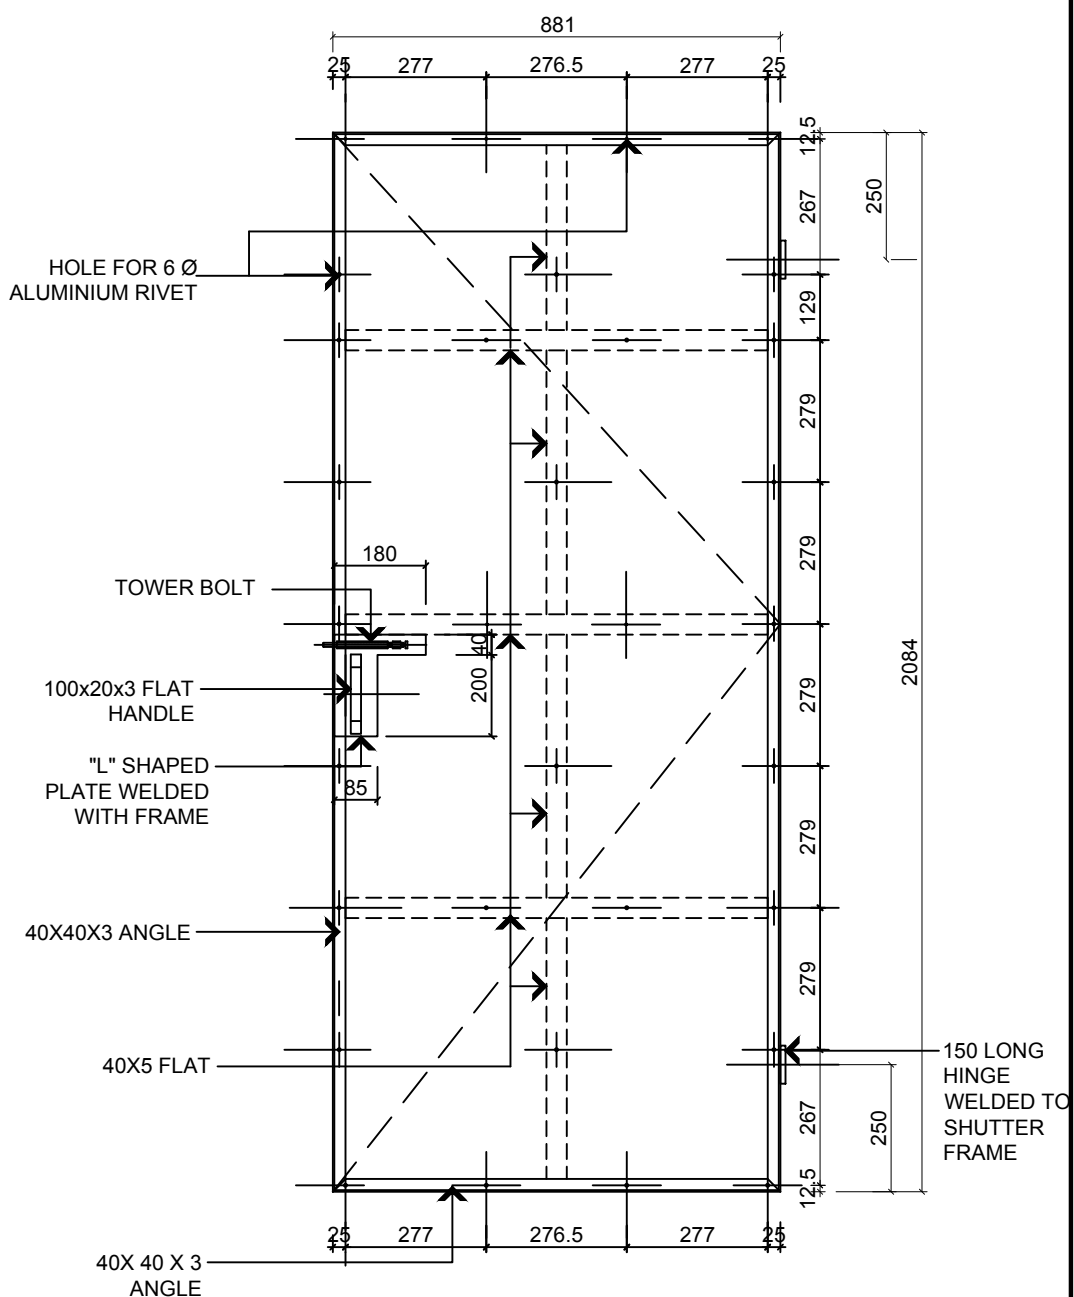


(LOOKING FROM INTSIDE)
SHUTTER ELEVATION

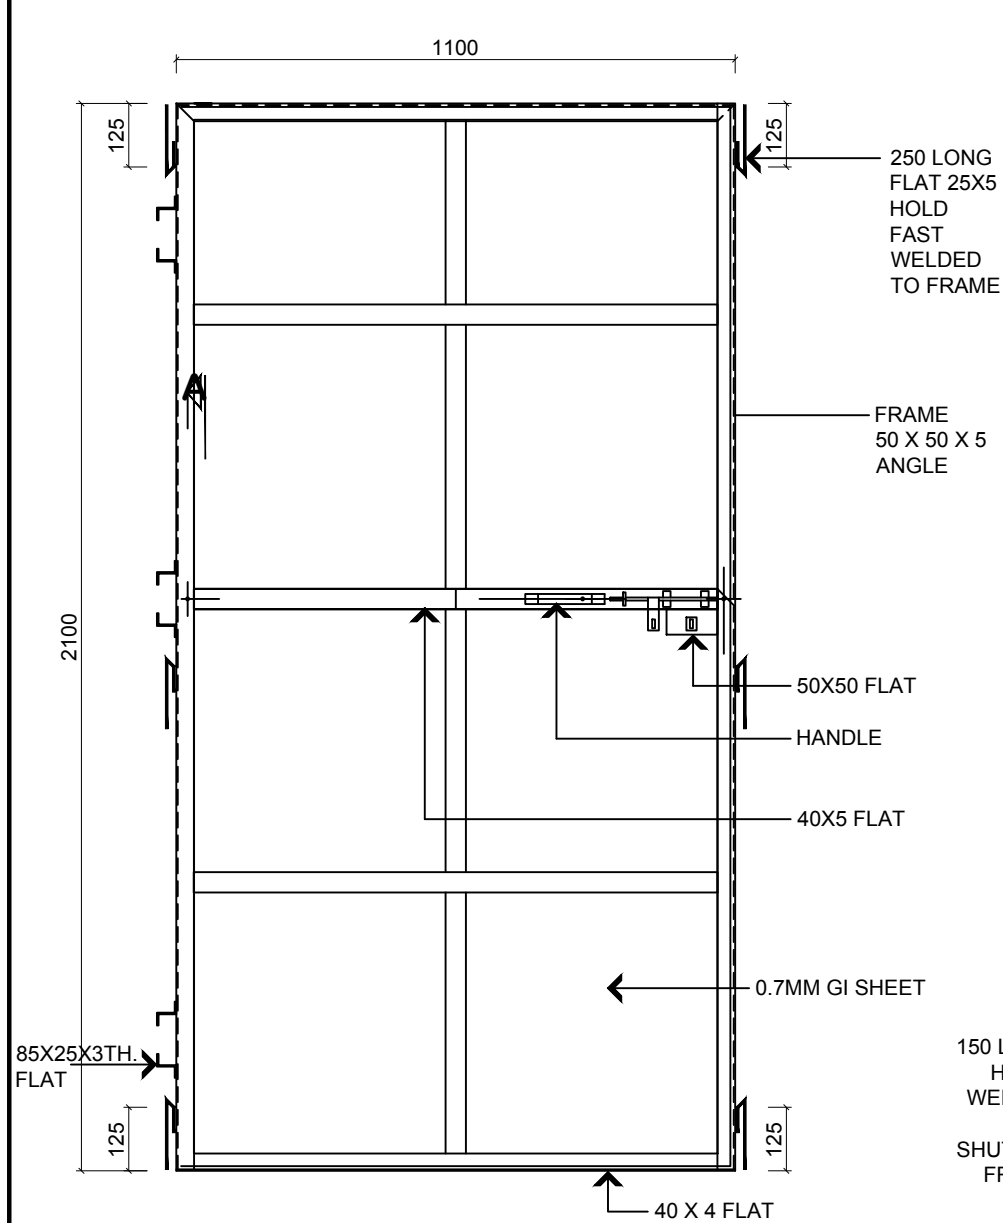

(FRAME ELEVATION LOOKING FROM
OUTSIDE)

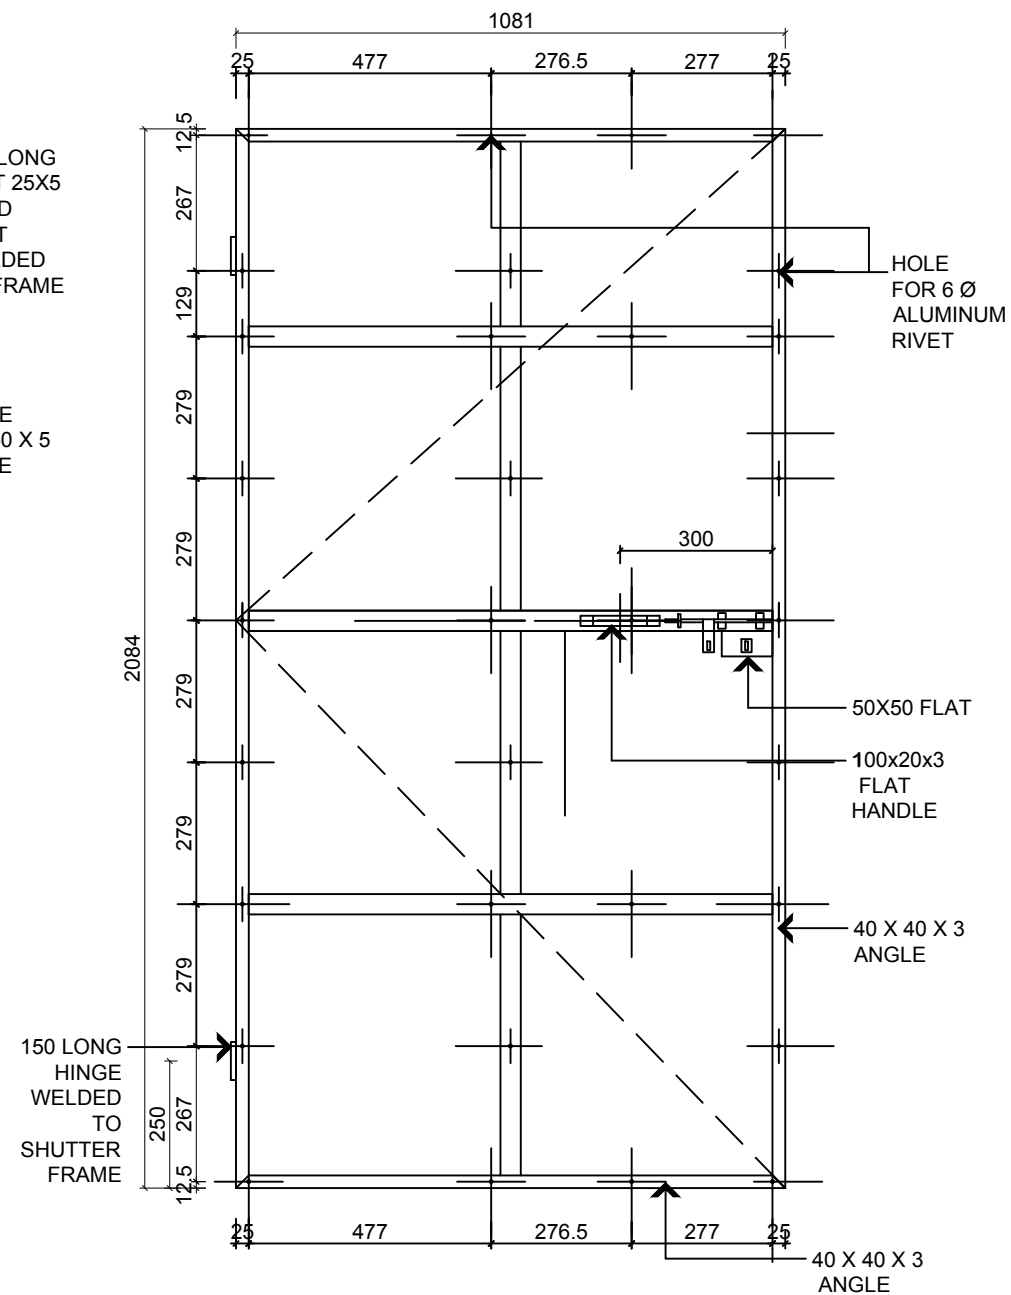


(LOOKING FROM OUTSIDE)
SHUTTER ELEVATION

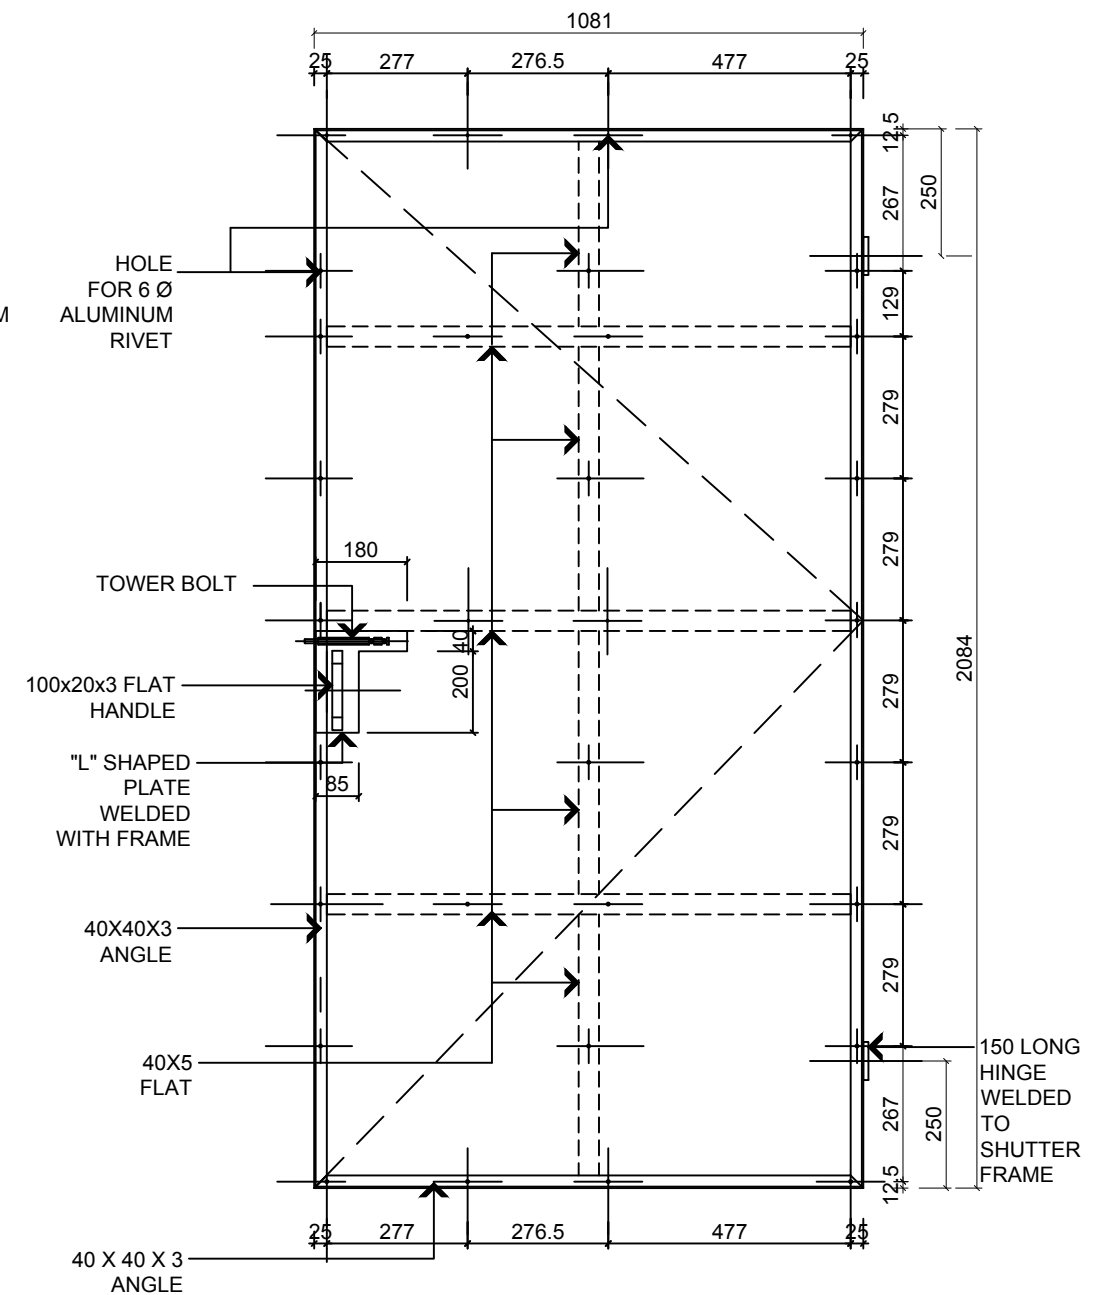

(LOOKING FROM INSIDE)
SHUTTER ELEVATION

DOOR (D)




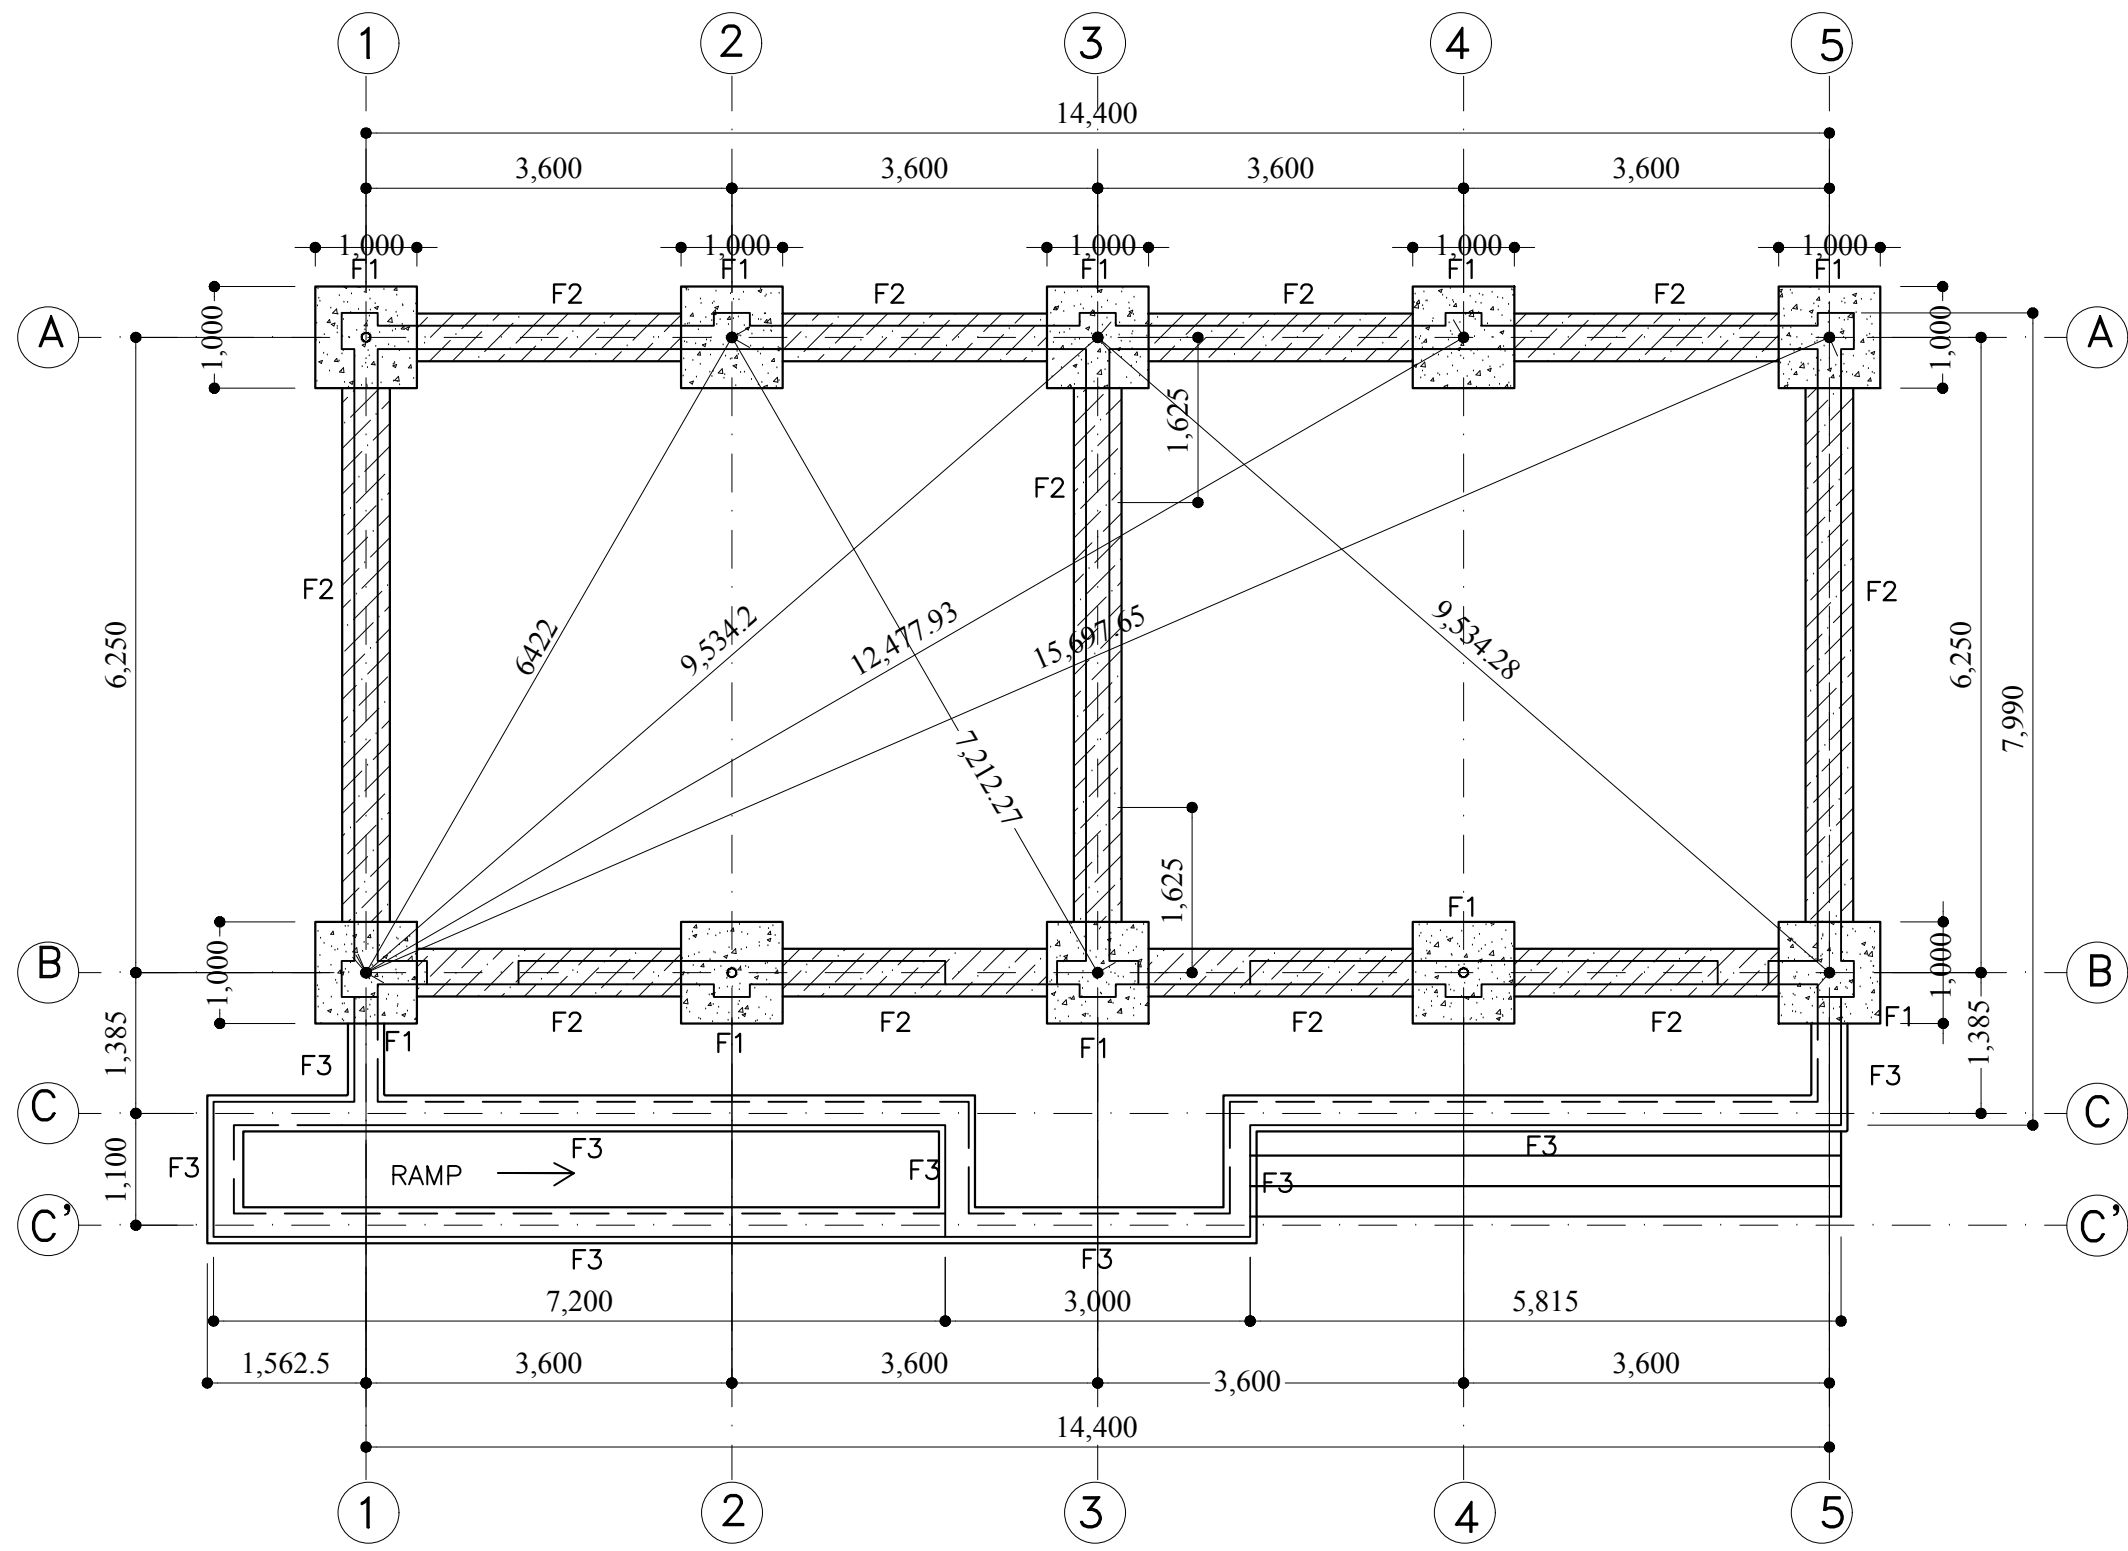


TRENCH PLAN




Government of Nepal Ministry of Education Central Level Project Implementation Unit (CLPIU) Gyaneshwor, Kathmandu	PROJECT : 1 Storey 2 Classrooms Revised (Oct 2017)	TITLE : TRENCH PLAN	Date : OCT 2017	Sheet No: 08
			Scale : 1:75	
			Designed by :	
			Checked by :	
			Approved by :	

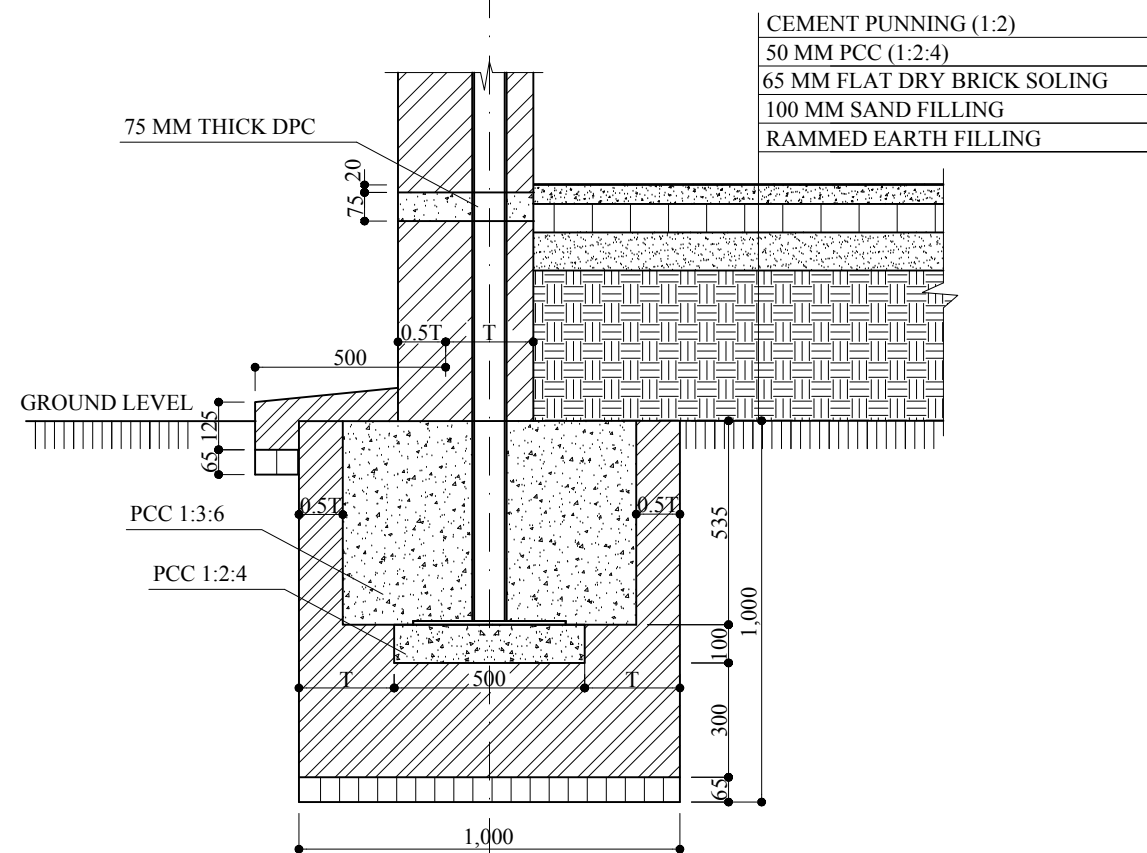


F1 TYPE

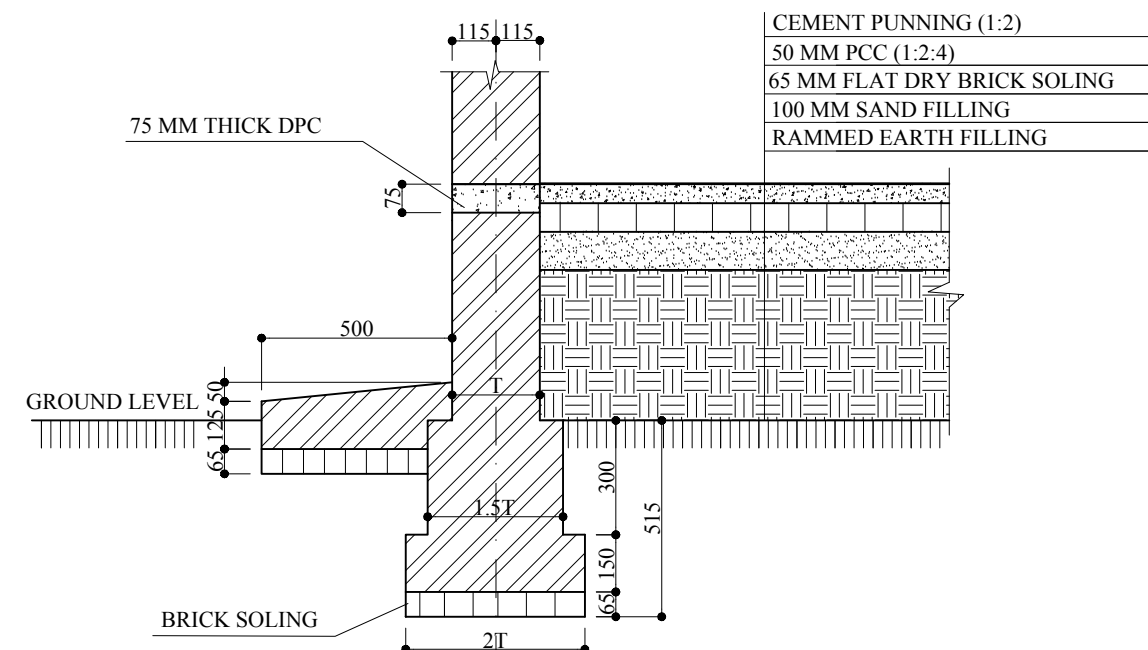

F2 TYPE




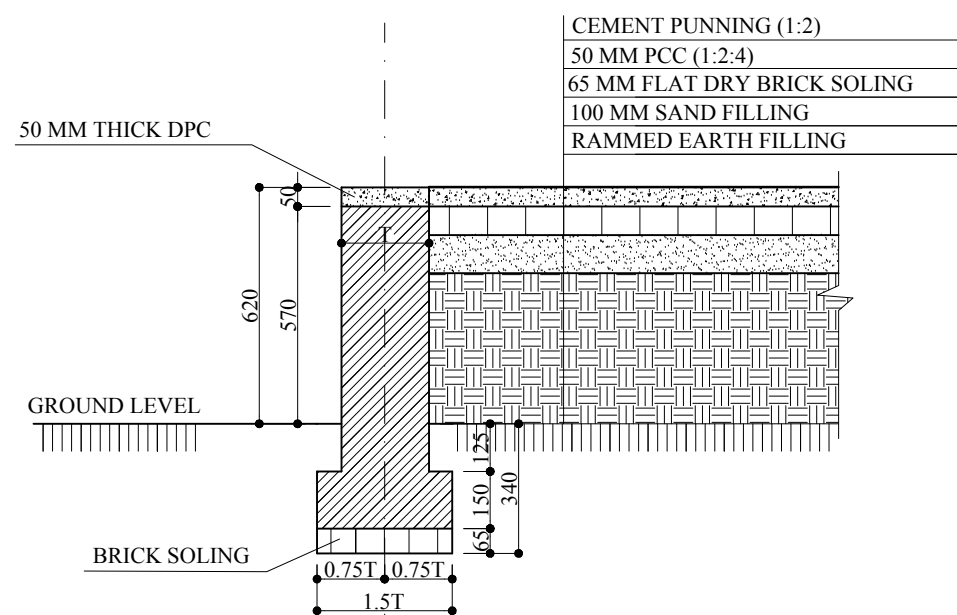


F3 TYPE


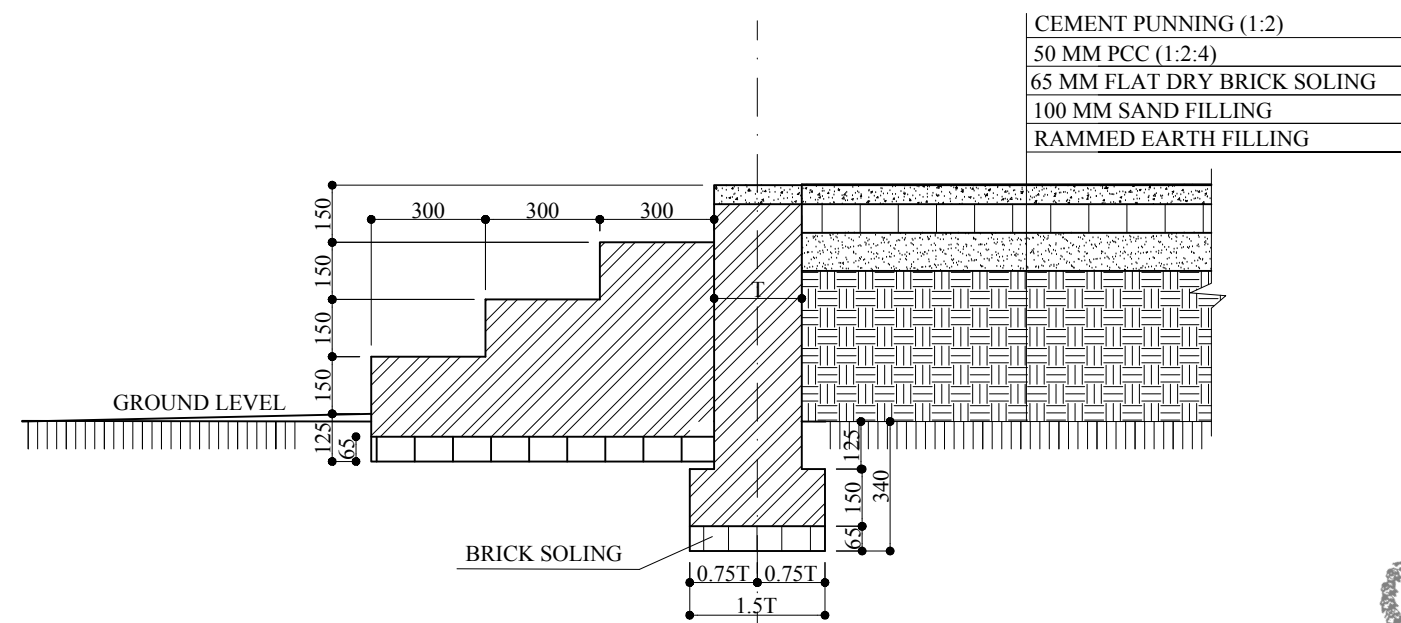


DETAIL OF STEPS



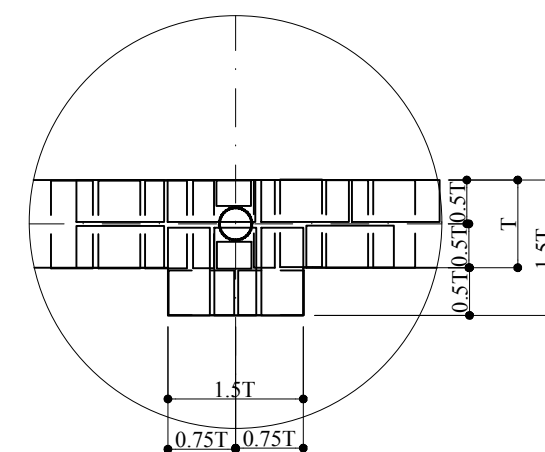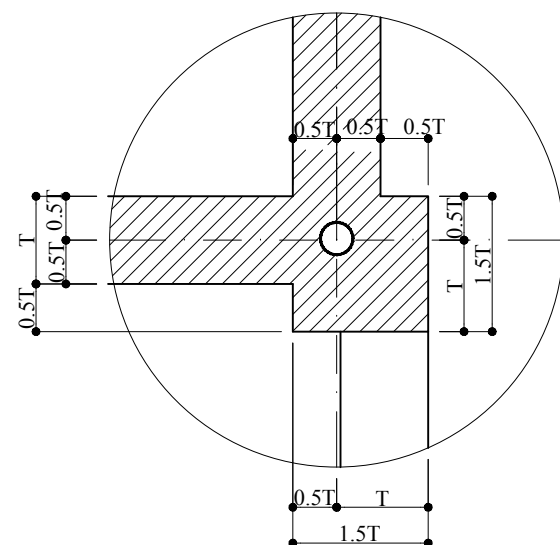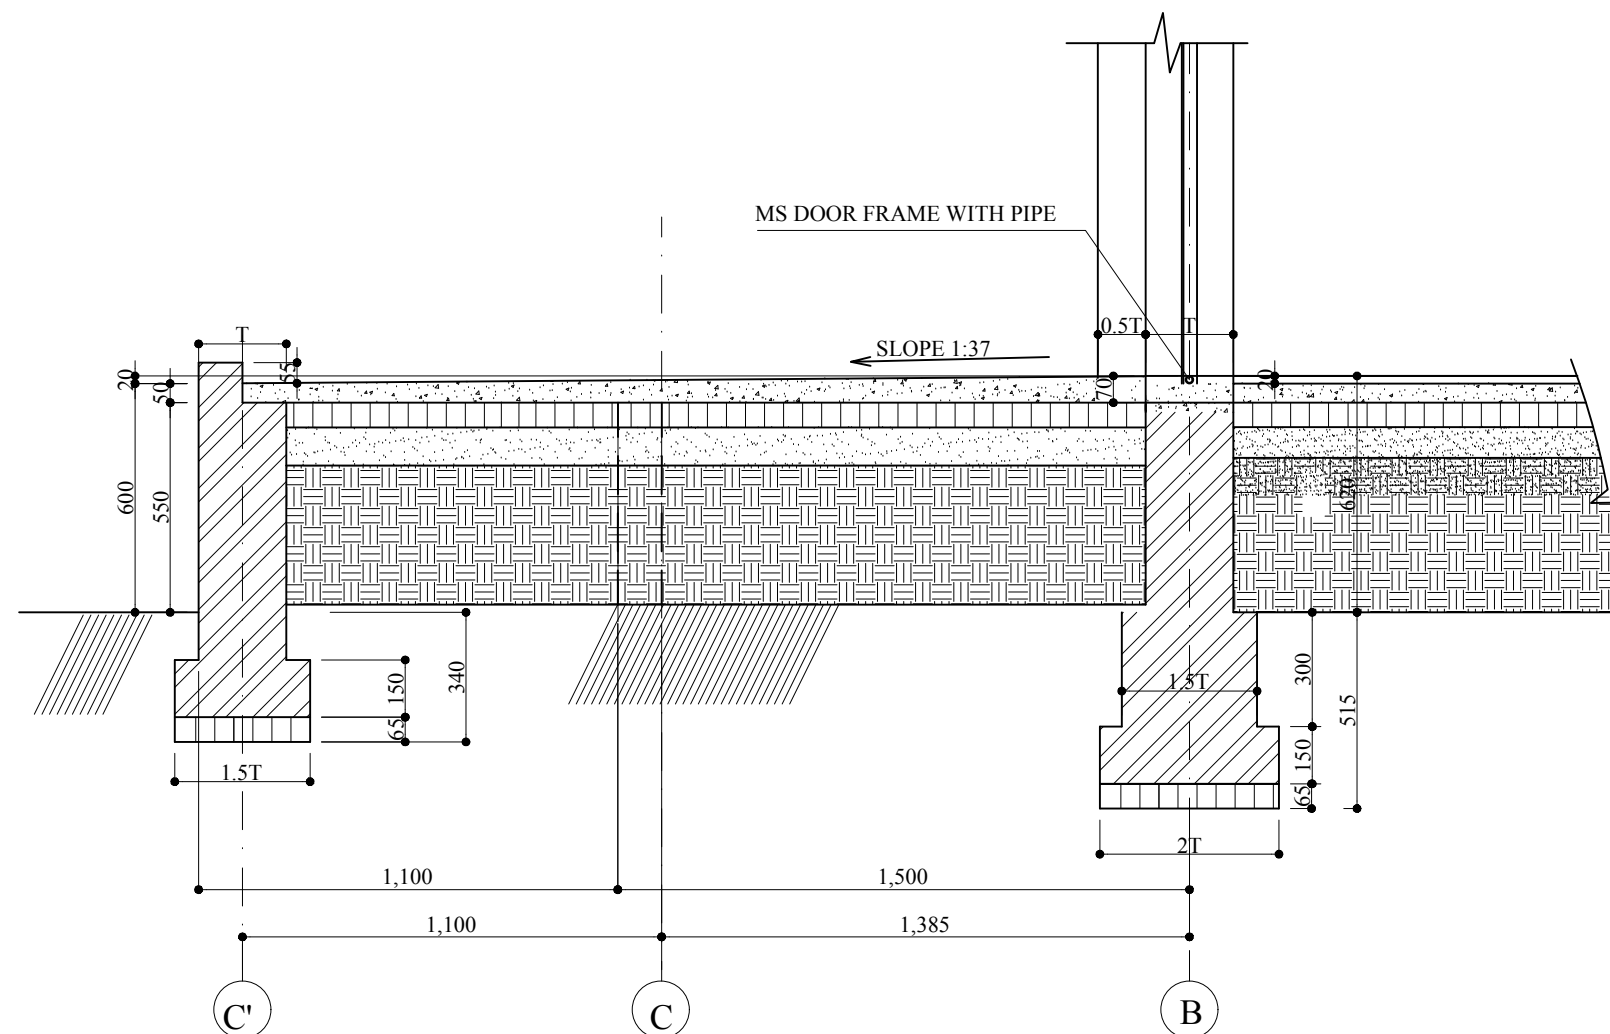
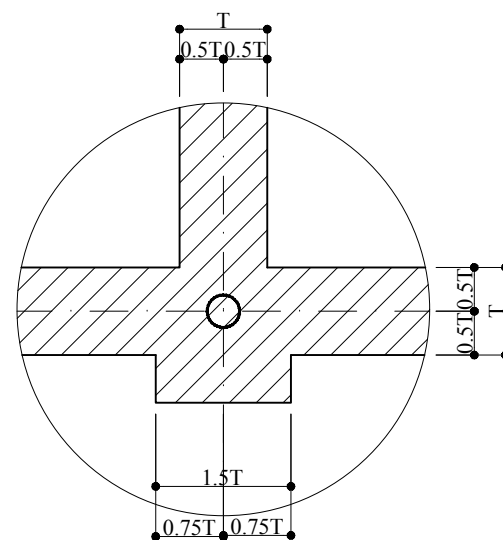


PLAN FOR DPC AND GABLE BAND

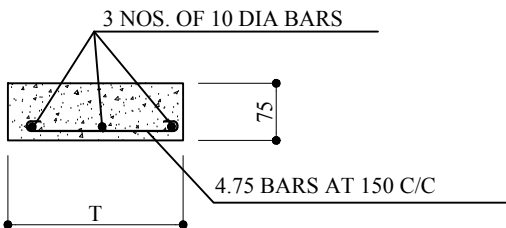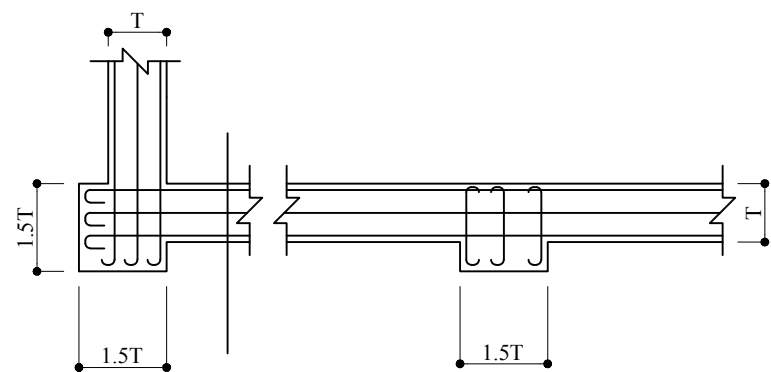


DPC AND GABLE BAND SECTION

PLAN FOR SILL AND LINTEL BAND

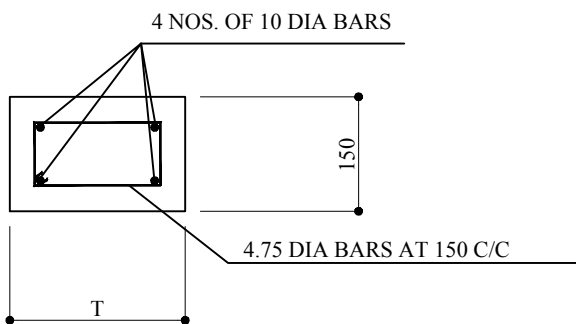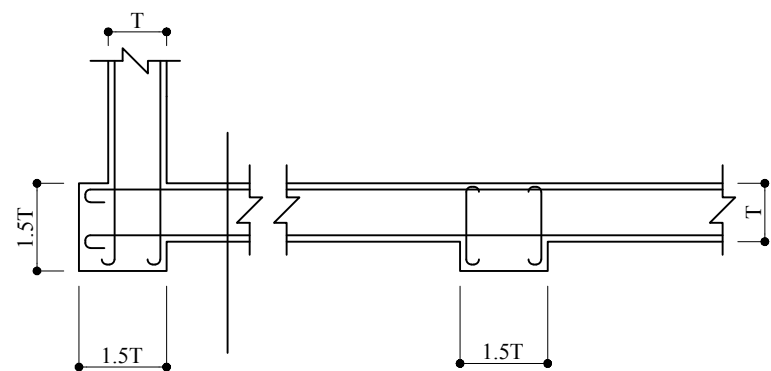


LINTEL BAND SECTION


STICHING BAND

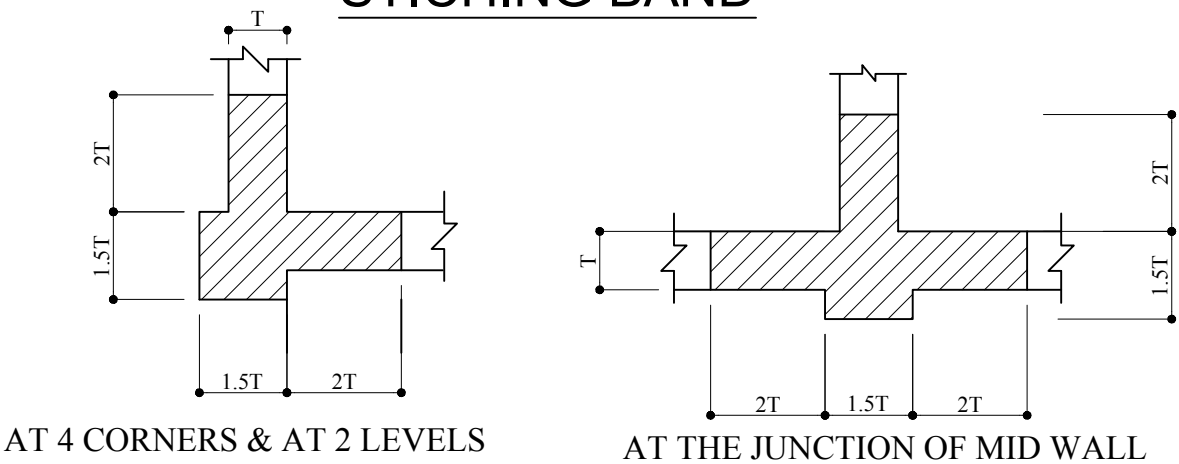

AT 4 CORNERS & AT 2 LEVELS

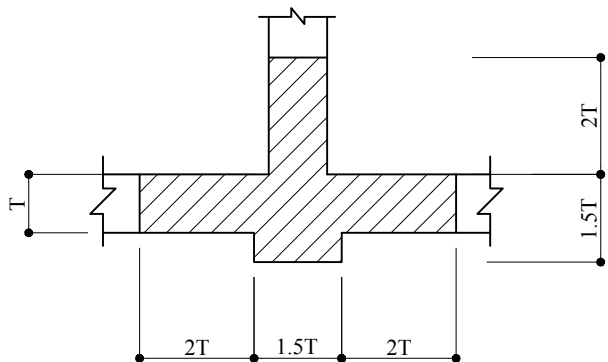


AT THE JUNCTION OF MID WALL

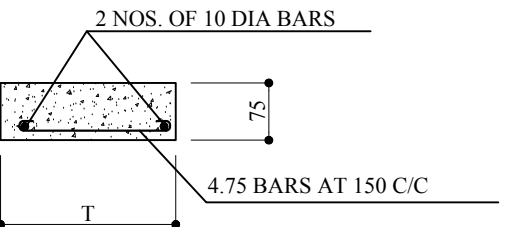


STICHING AND SILL BAND SECTION






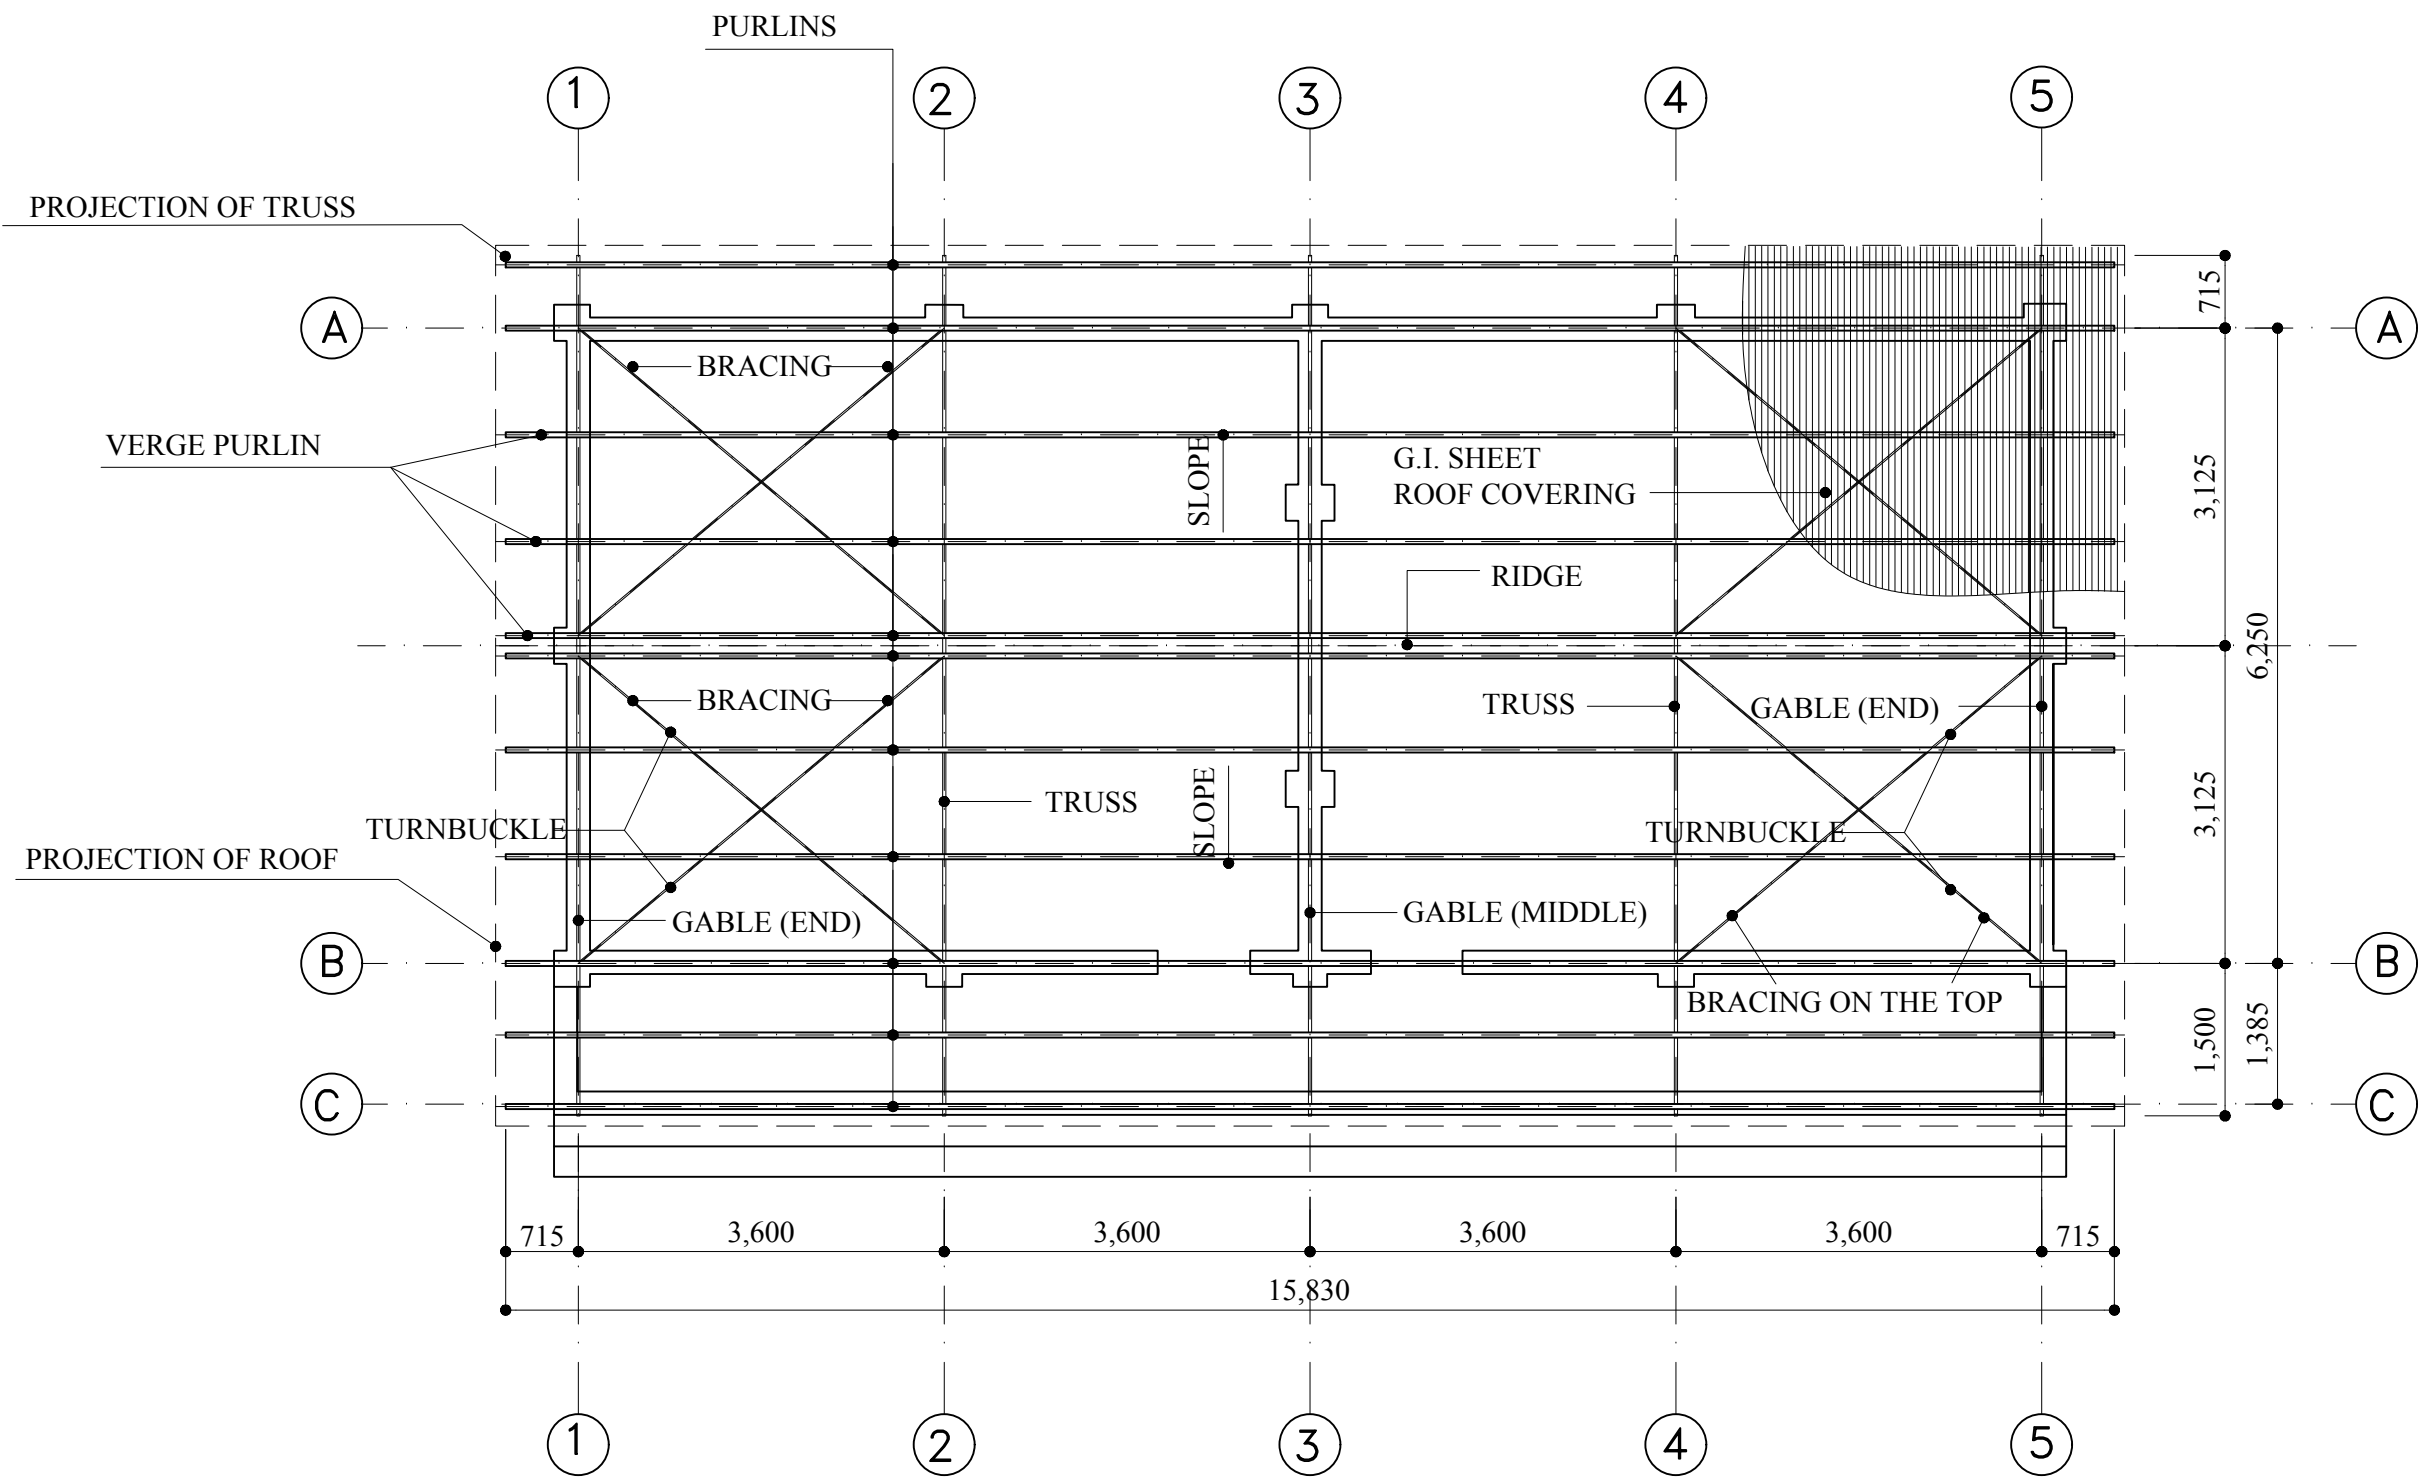


STRUCTURAL PLAN OF TRUSS




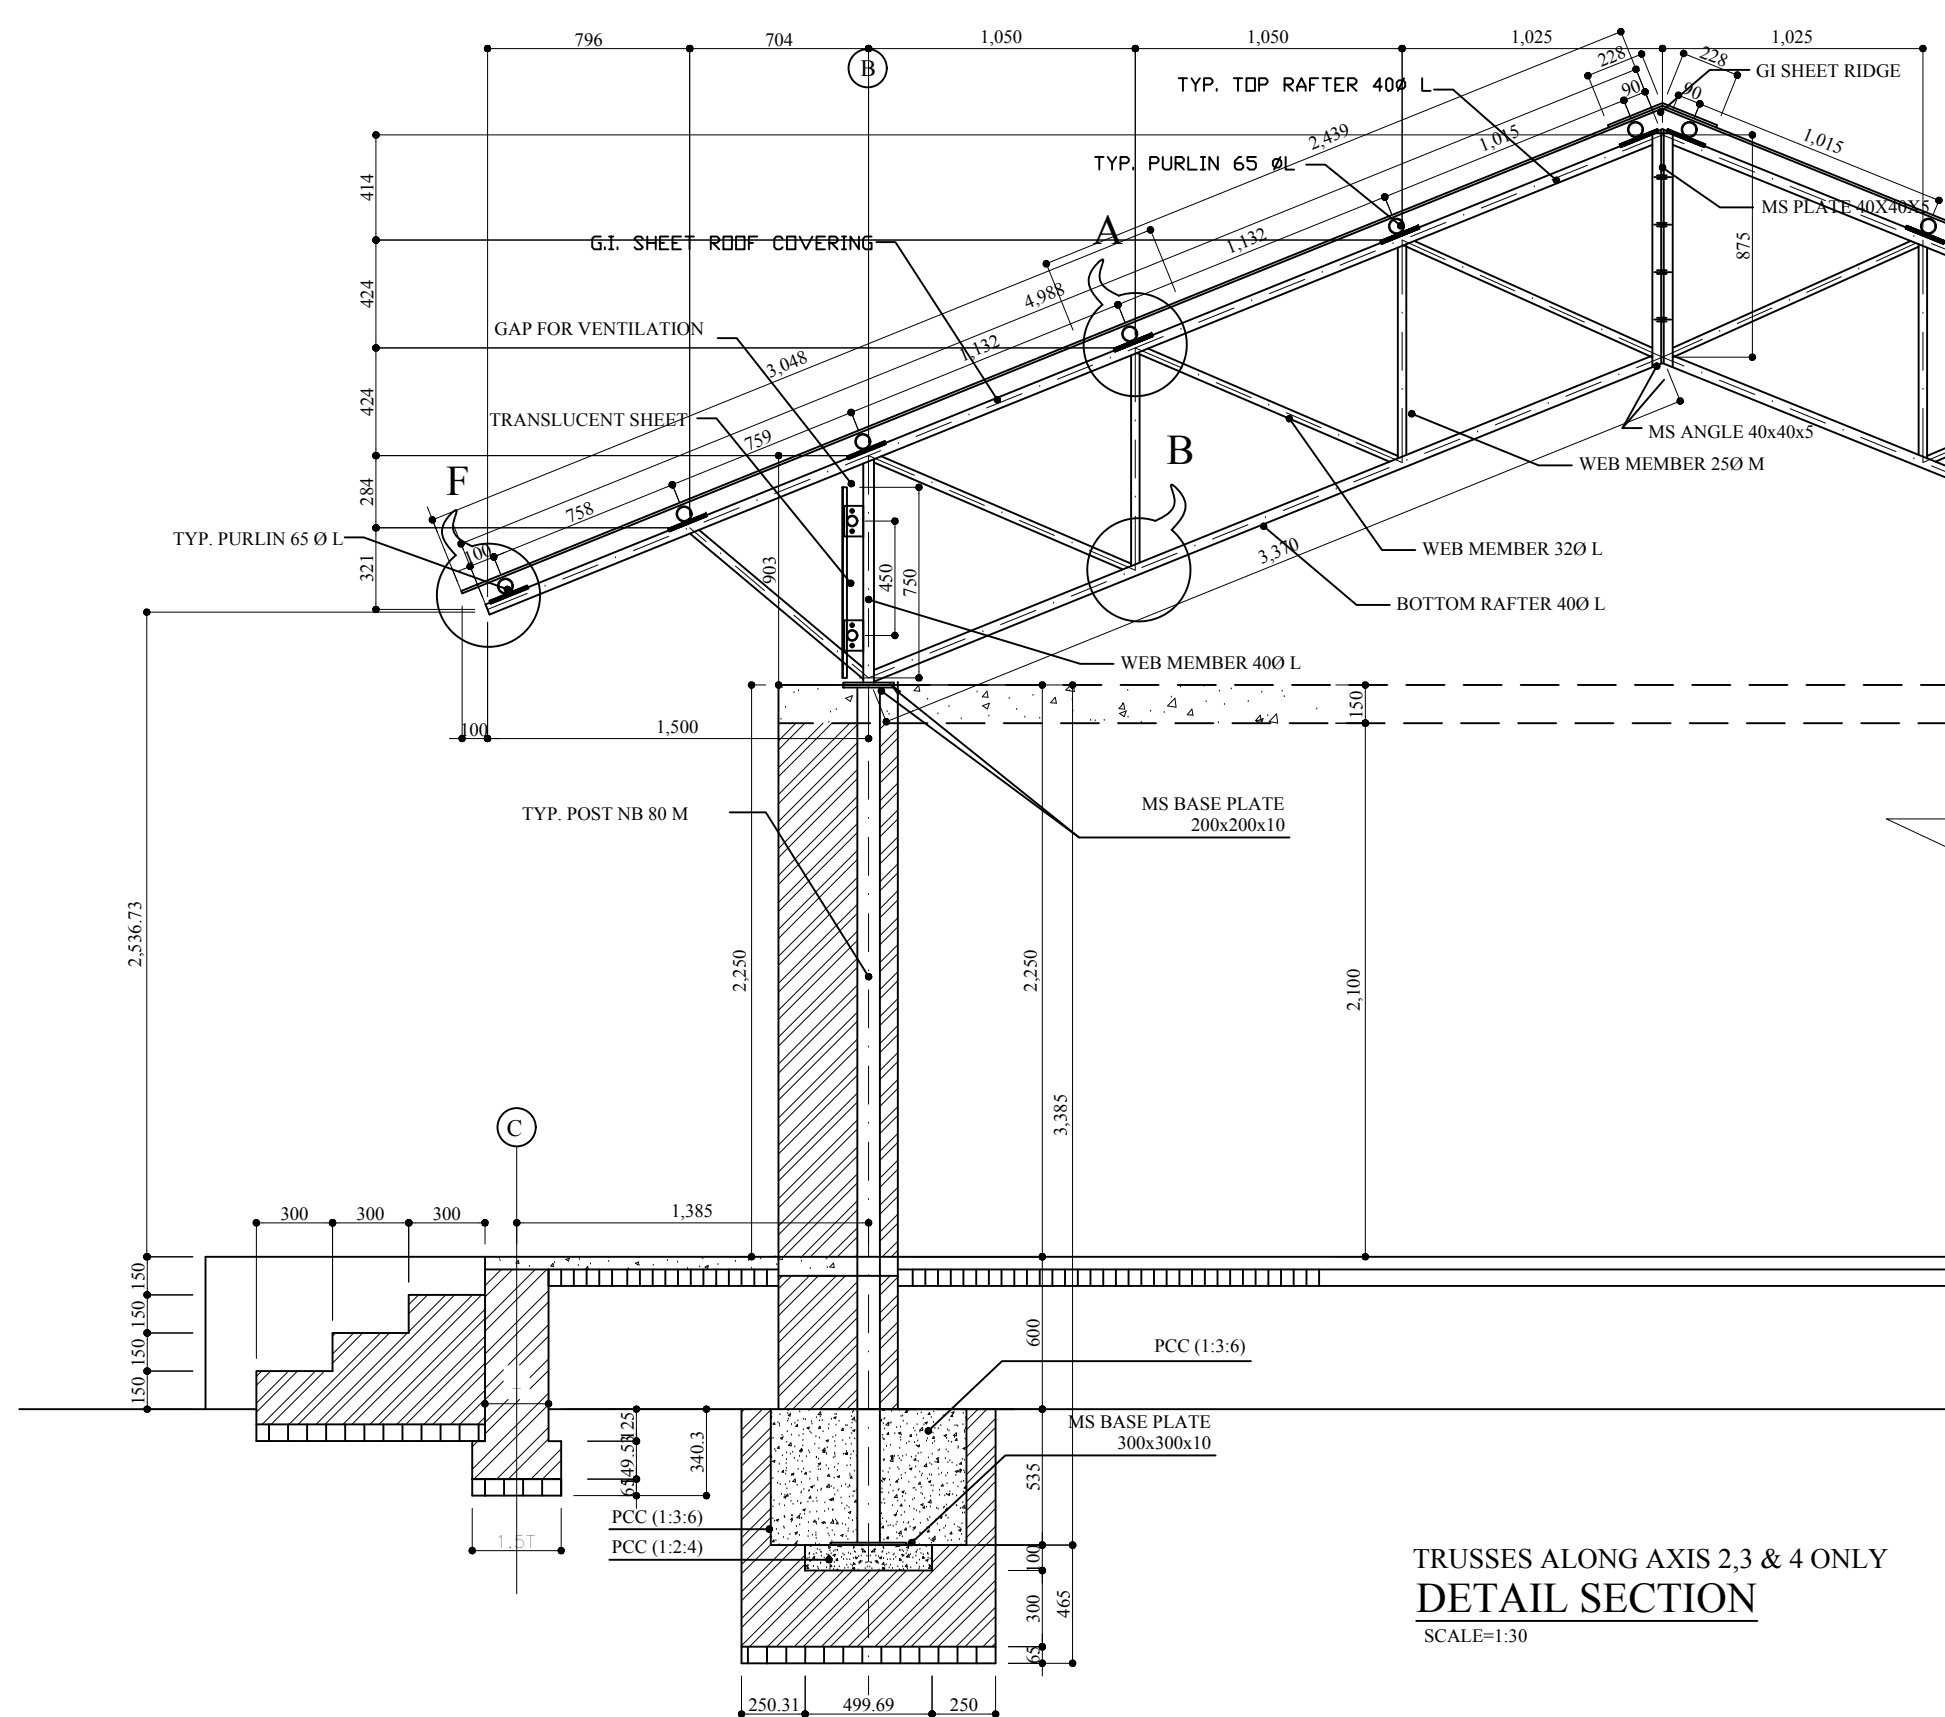

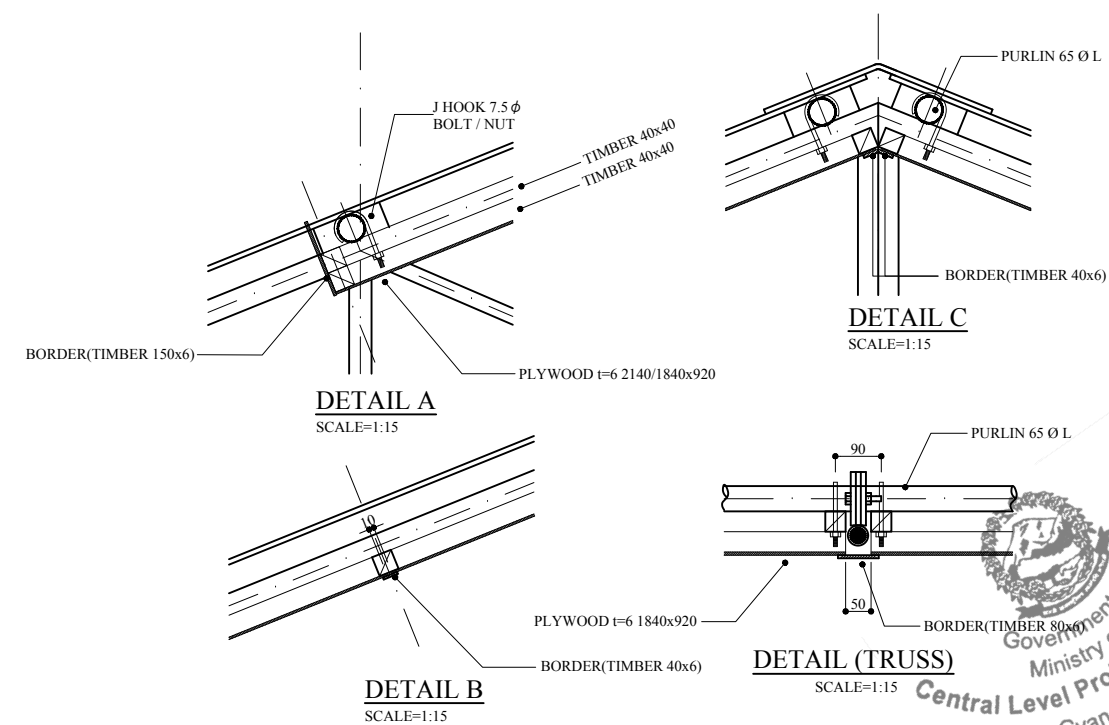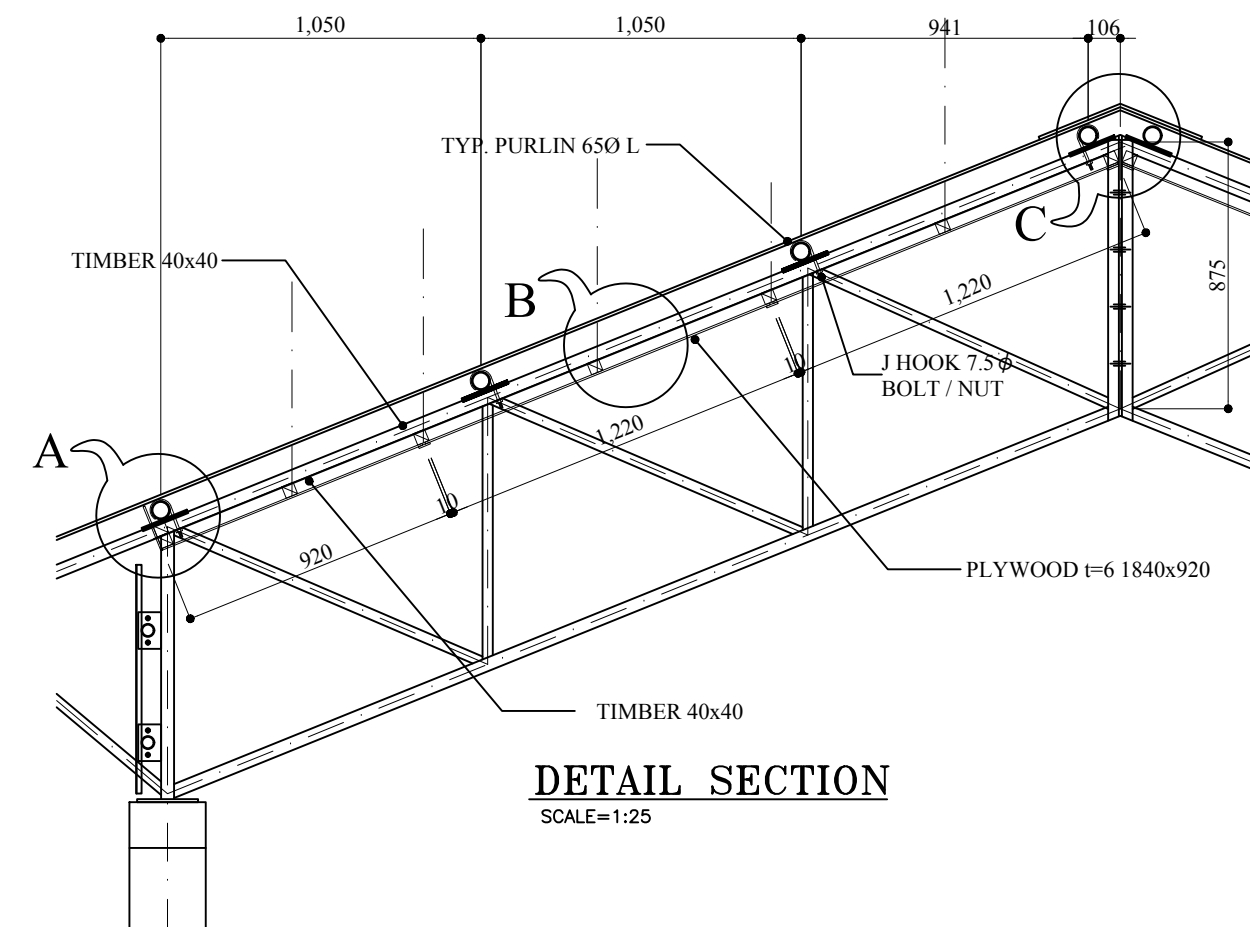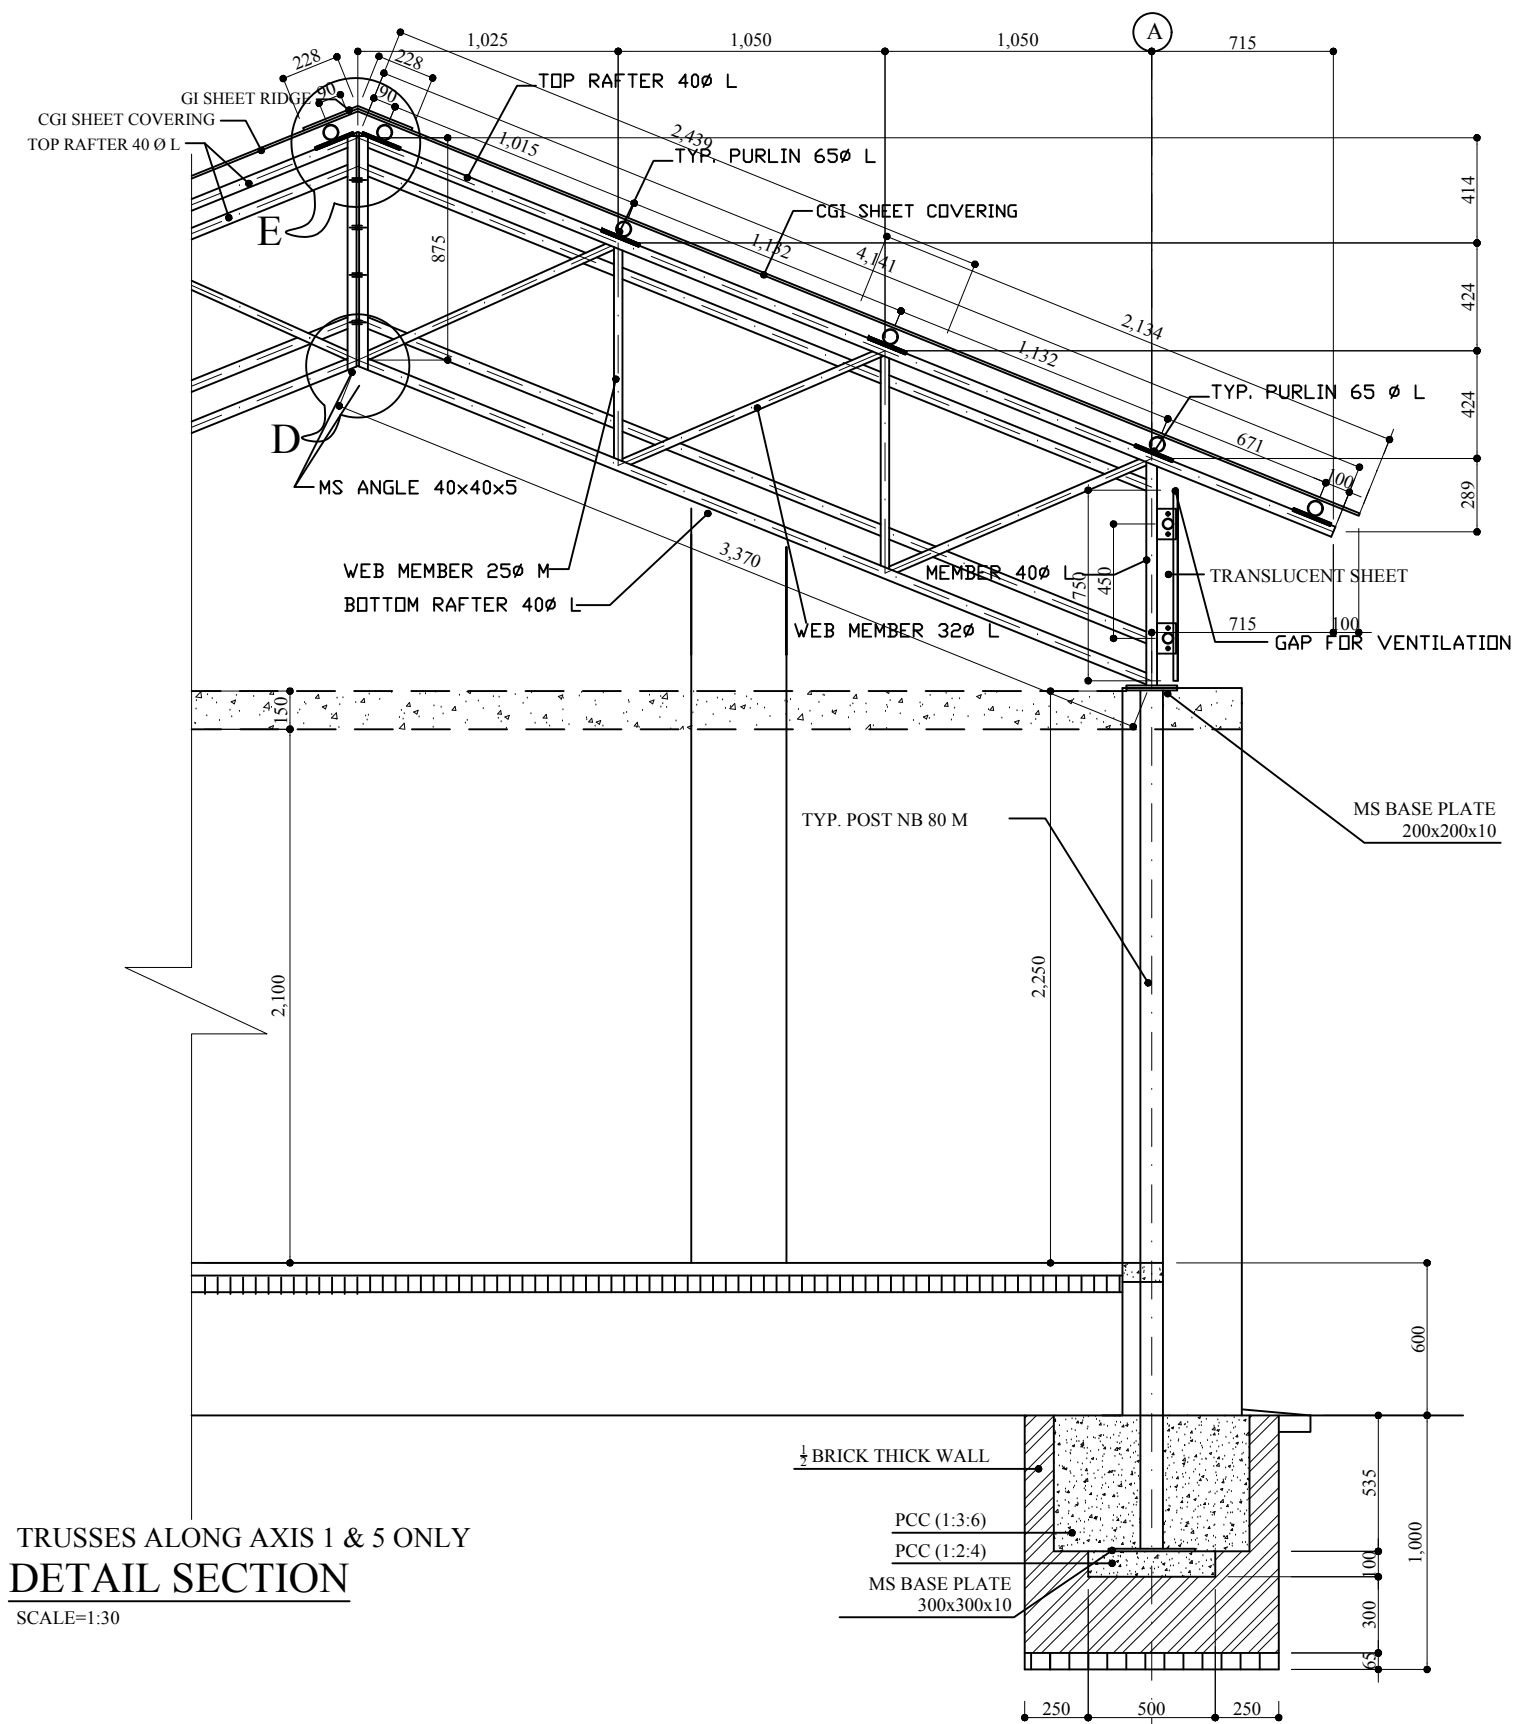


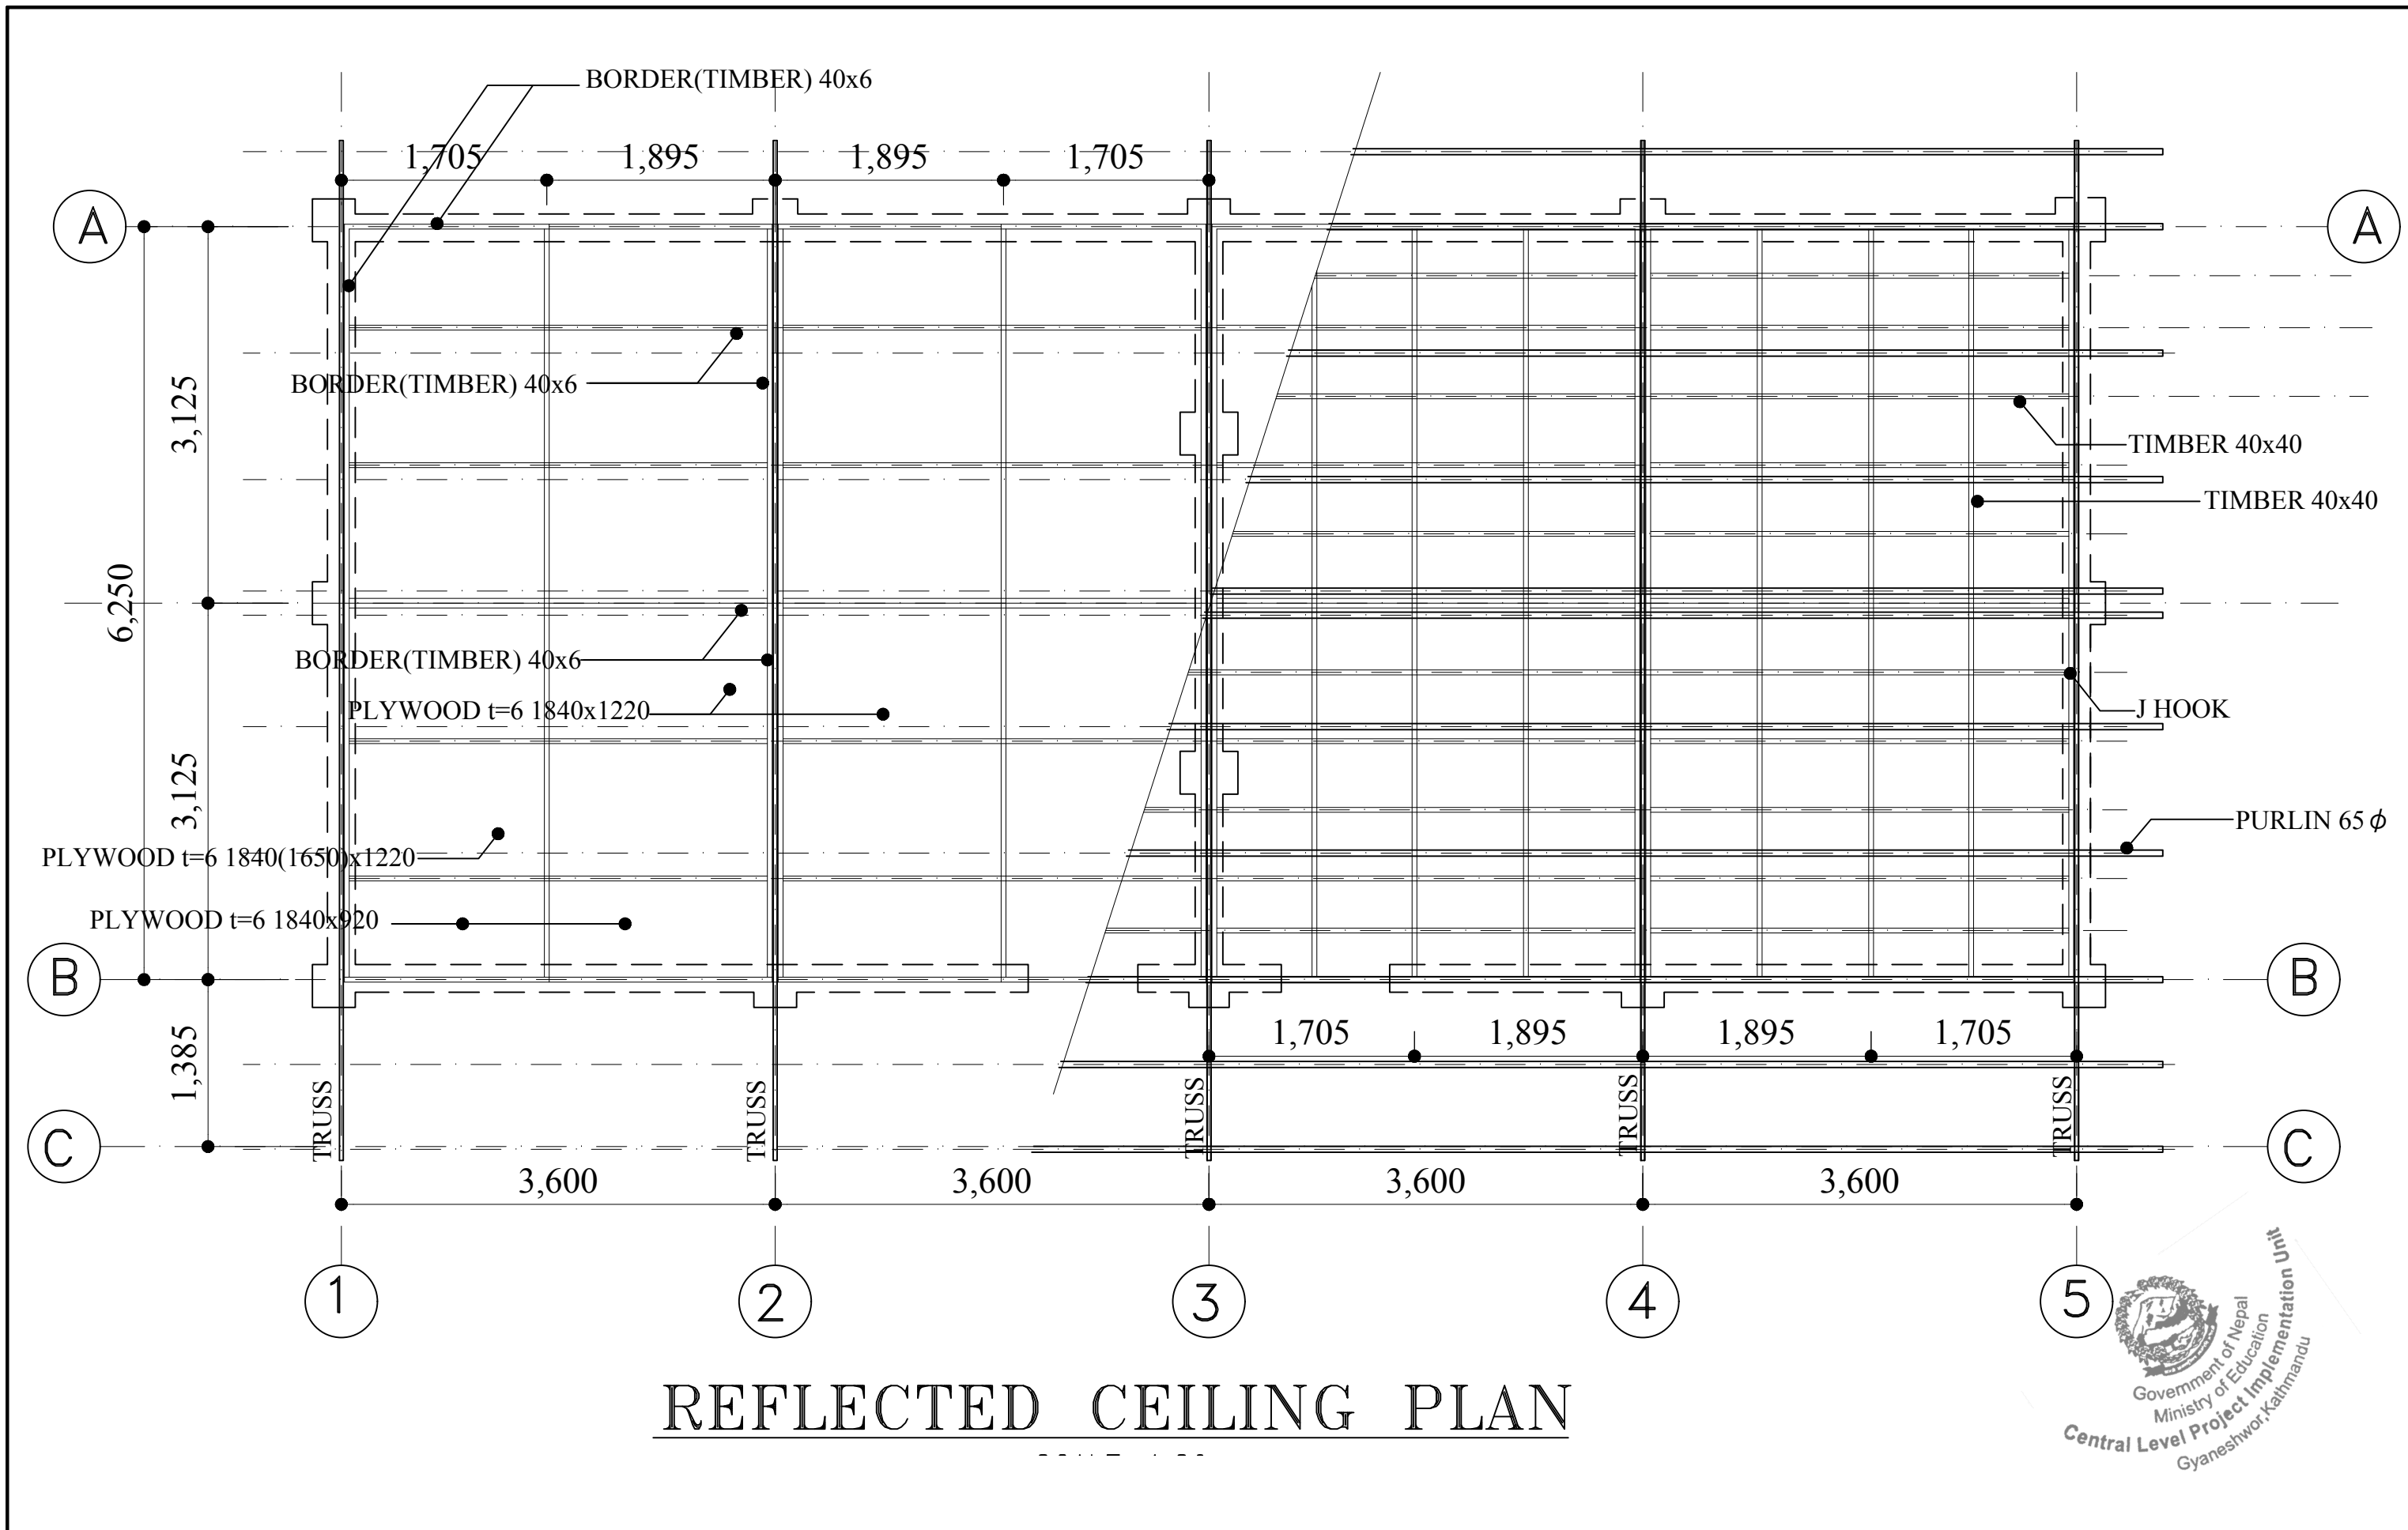


Government of Nepal Ministry of Education Central Level Project Implementation Unit (CLPIU) Gyaneshwor, Kathmandu	PROJECT : 1 Storey 2 Classrooms Revised (Oct 2017)	TITLE : DETAIL SECTION OF TRUSS	Date : OCT 2017	Sheet No: 15
			Scale : 1:50	
			Designed by :	
			Checked by :	
			Approved by :	

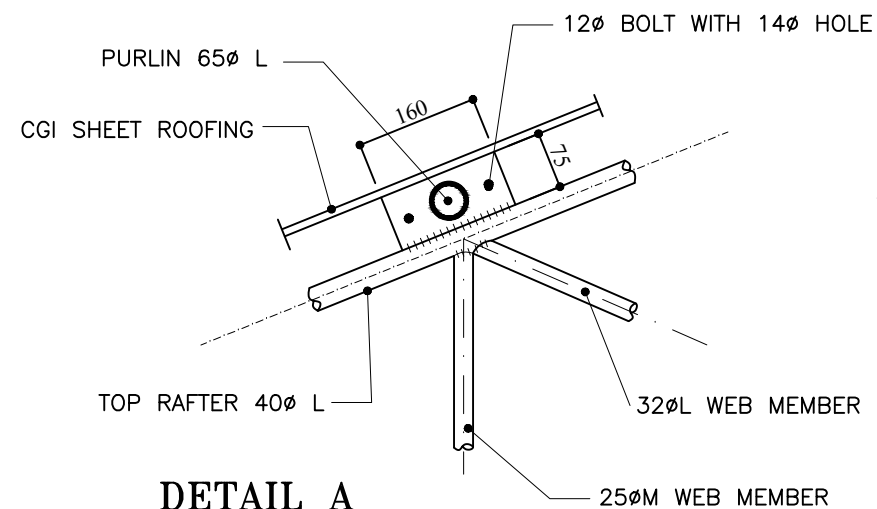


DETAIL A
SCALE=1:10

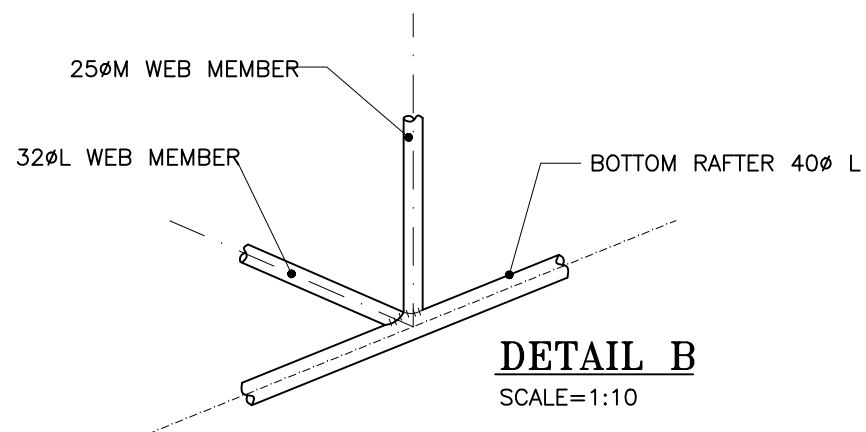


DETAIL B
SCALE=1:10

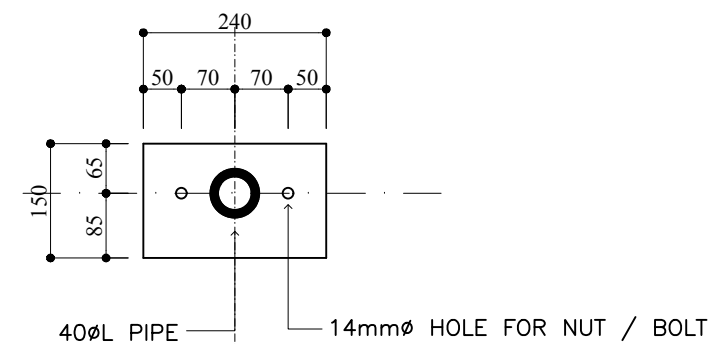


**240 x 150 x 6mm
MS PLATE ELEVATION**
SCALE=1:5

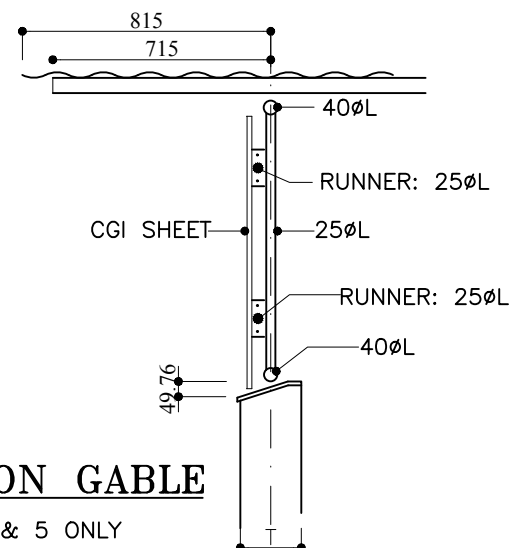


DETAIL ON GABLE
ALONG AXIS 1 & 5 ONLY
SCALE=1:25

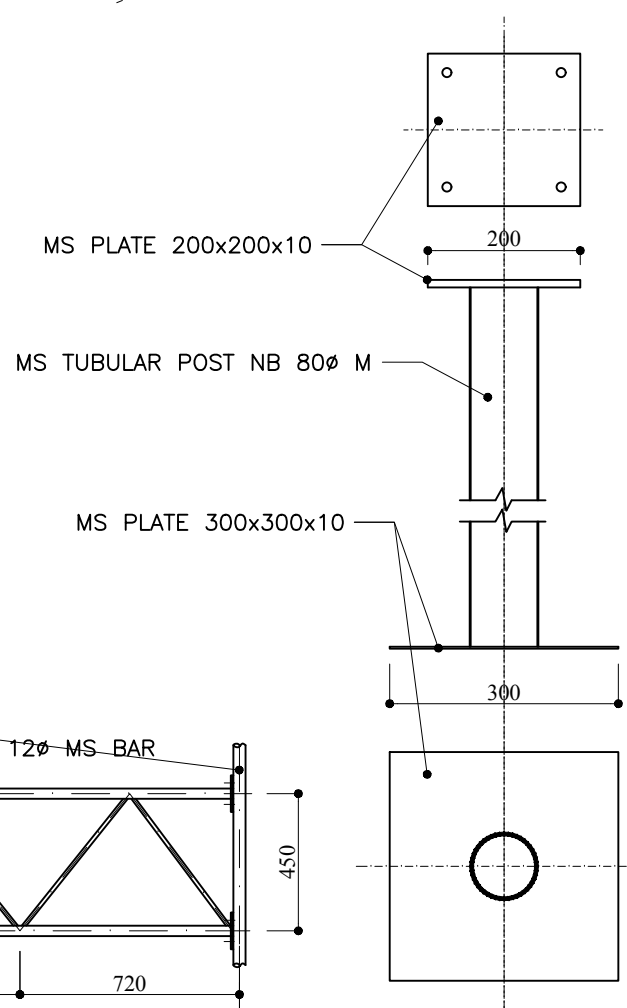


DETAIL OF POST
SCALE=1:10

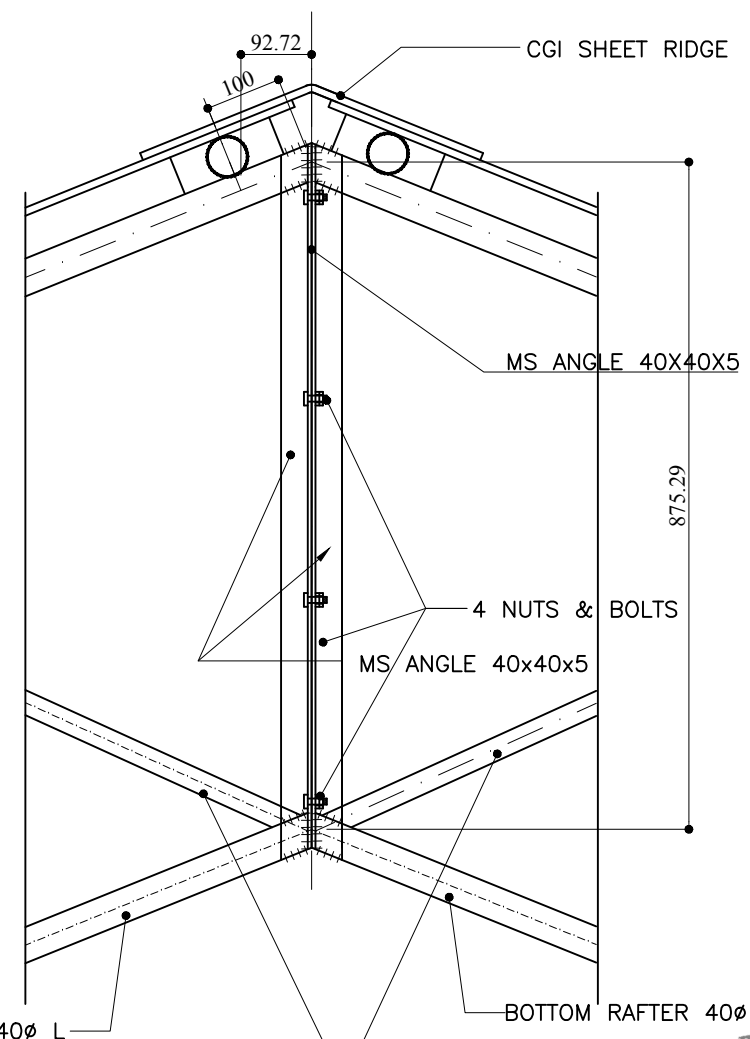


DETAIL D
SCALE=1:10









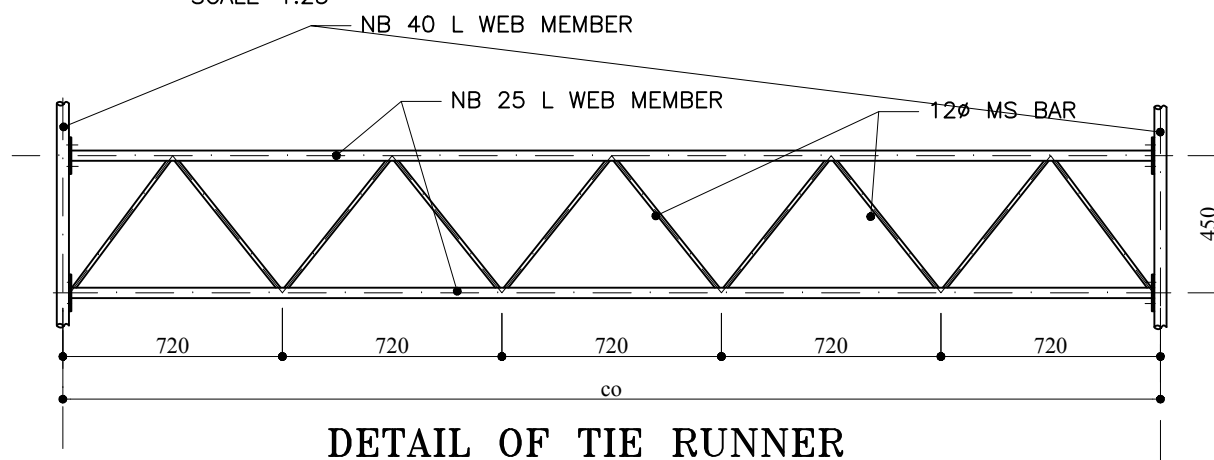


DETAIL OF TIE RUNNER
SCALE=1:25

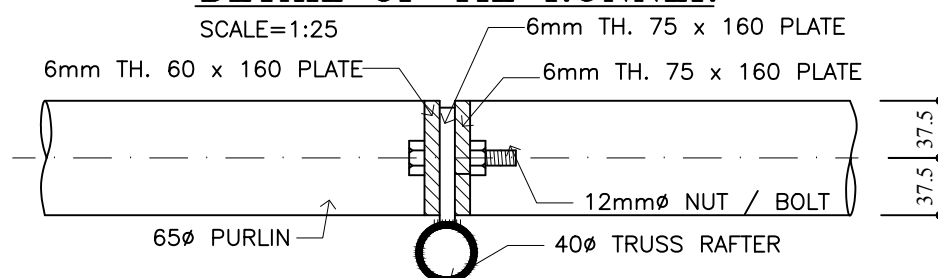


PURLIN JOINT DETAILS
SCALE=1:5

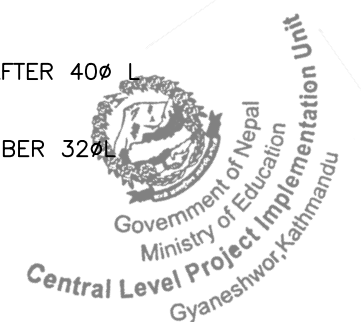

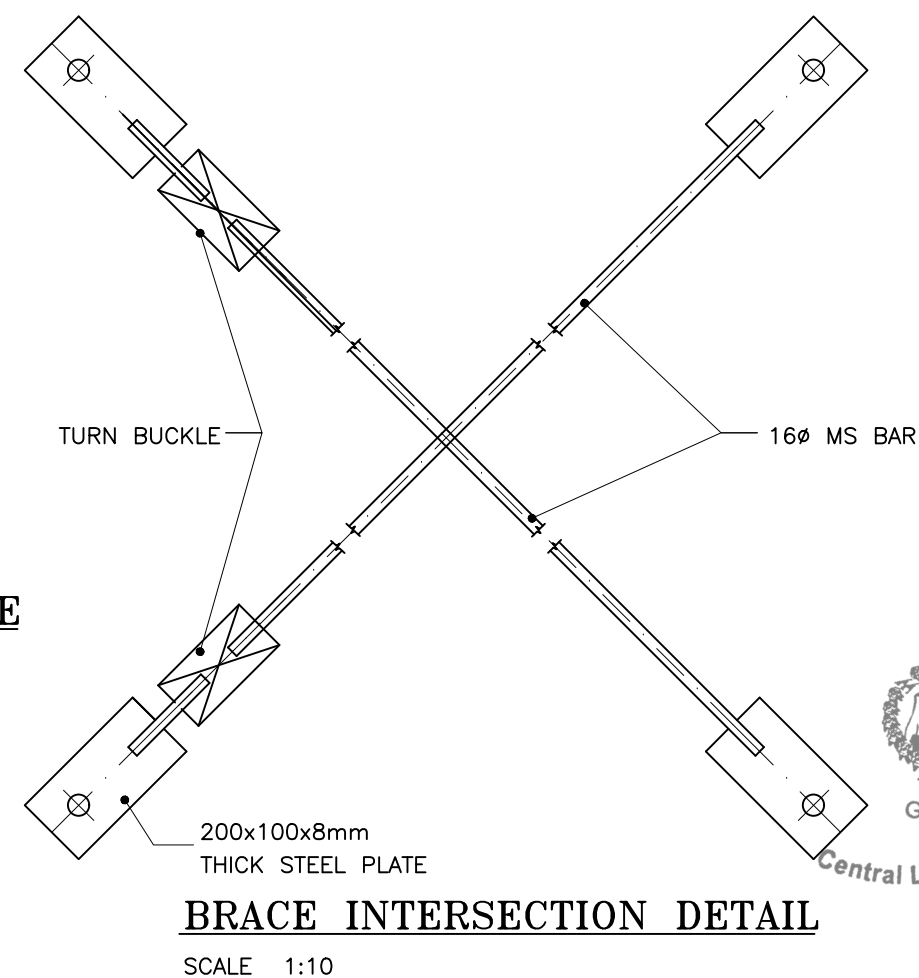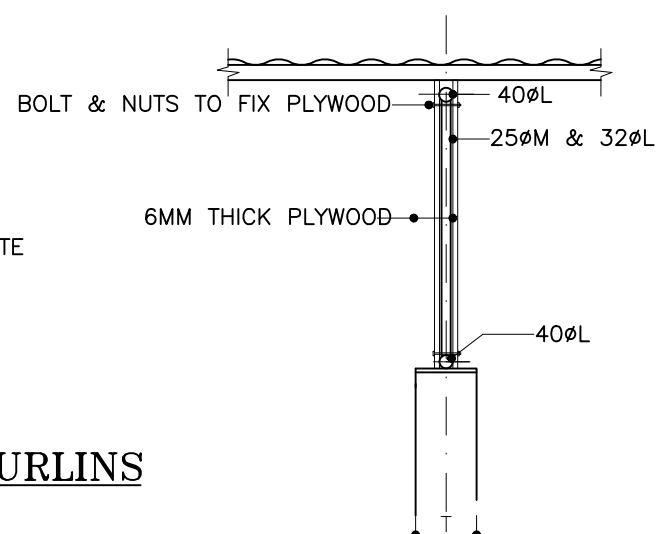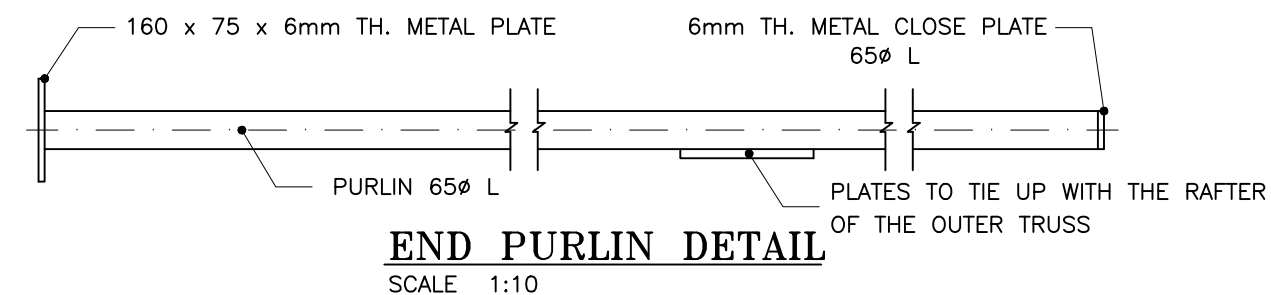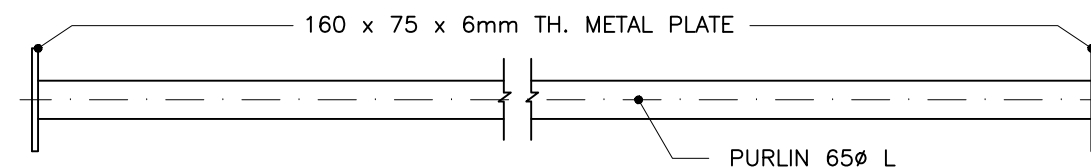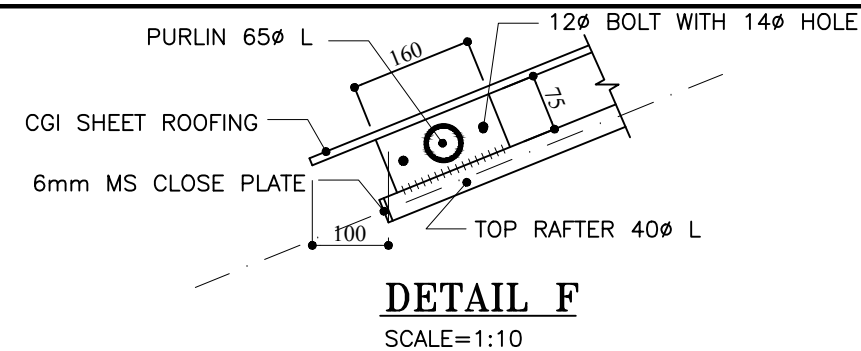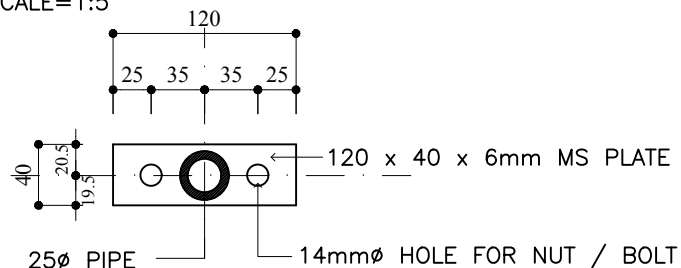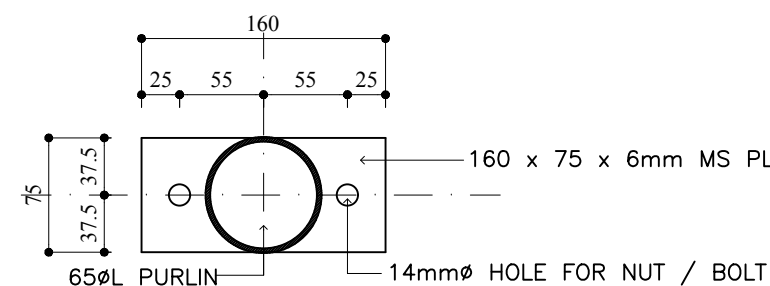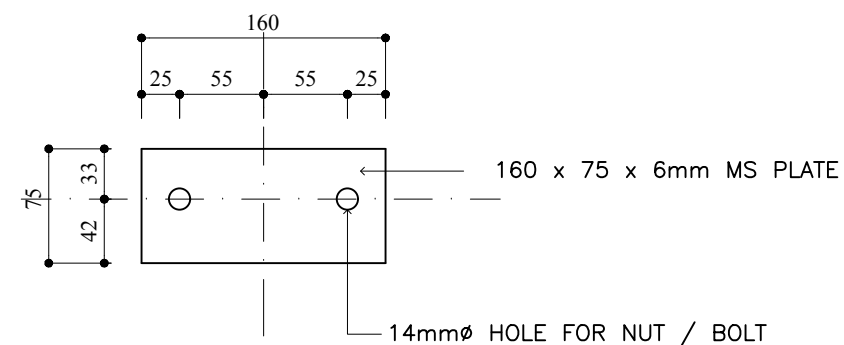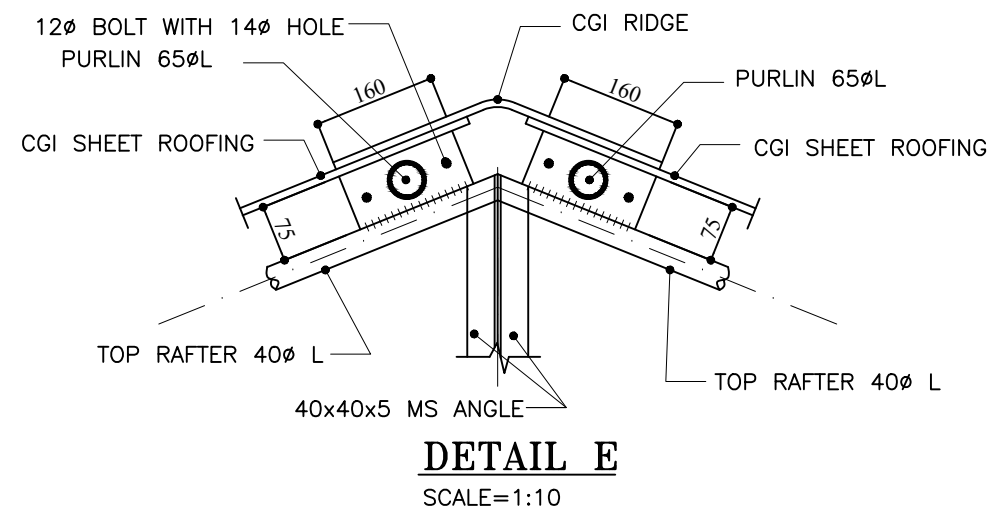

Government of Nepal
Ministry of Education
Central Level Project Implementation Unit
Gyaneshwor, Kathmandu

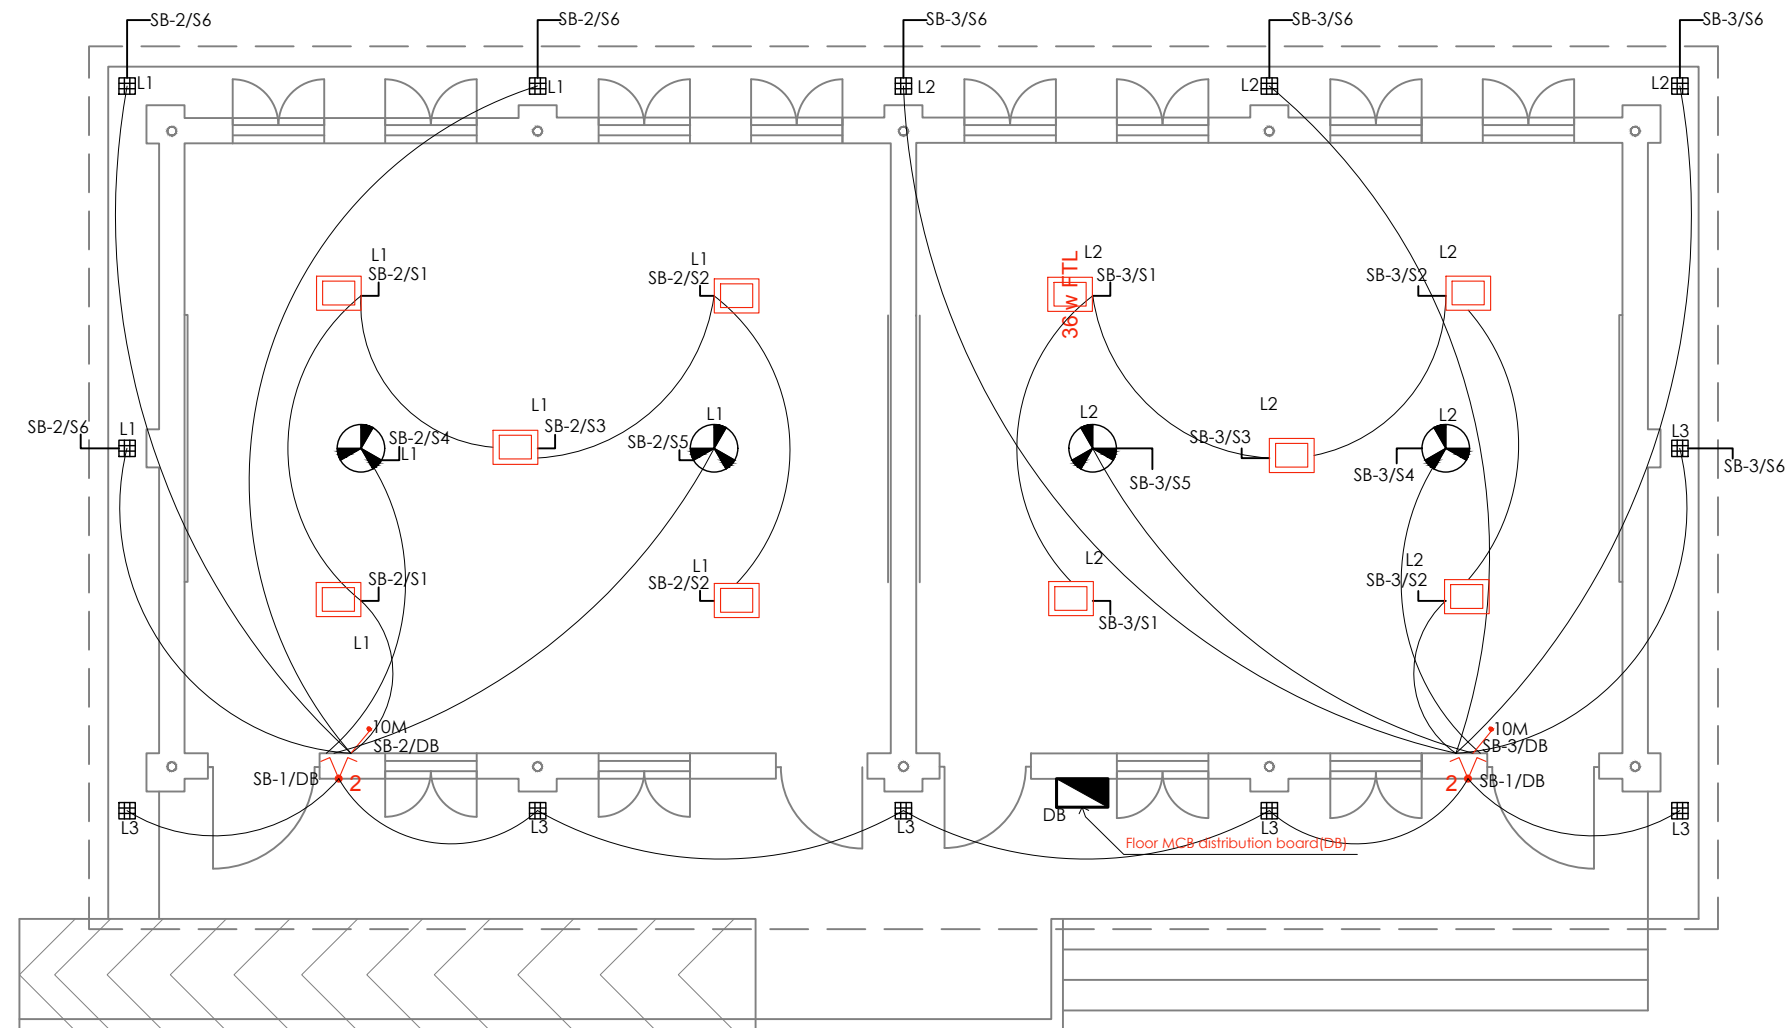


LIGHT POINT LAYOUT PLAN

1. PVC PIPE OF 20 mm dia 2MM THICK FOR CONCEALED WIRING SHOULD BE USED
2. LIGHT/FAN/5A/16A SOCKET POINT 2X2.5 SQ. MM+1X 1.5 SQ MM(LNE)

LEGEND

S.N.	Particulars	Symbol
1	24 W LED Panel Light	
2	Floor MCB distribution board(DB)	
3	One way modular switch(Multi-gang)	
4	Two way modular switch	
5	6/16A 5 Pin switch socket outlet	
6	Ceiling Fan	
7	9W Square type LED Light	

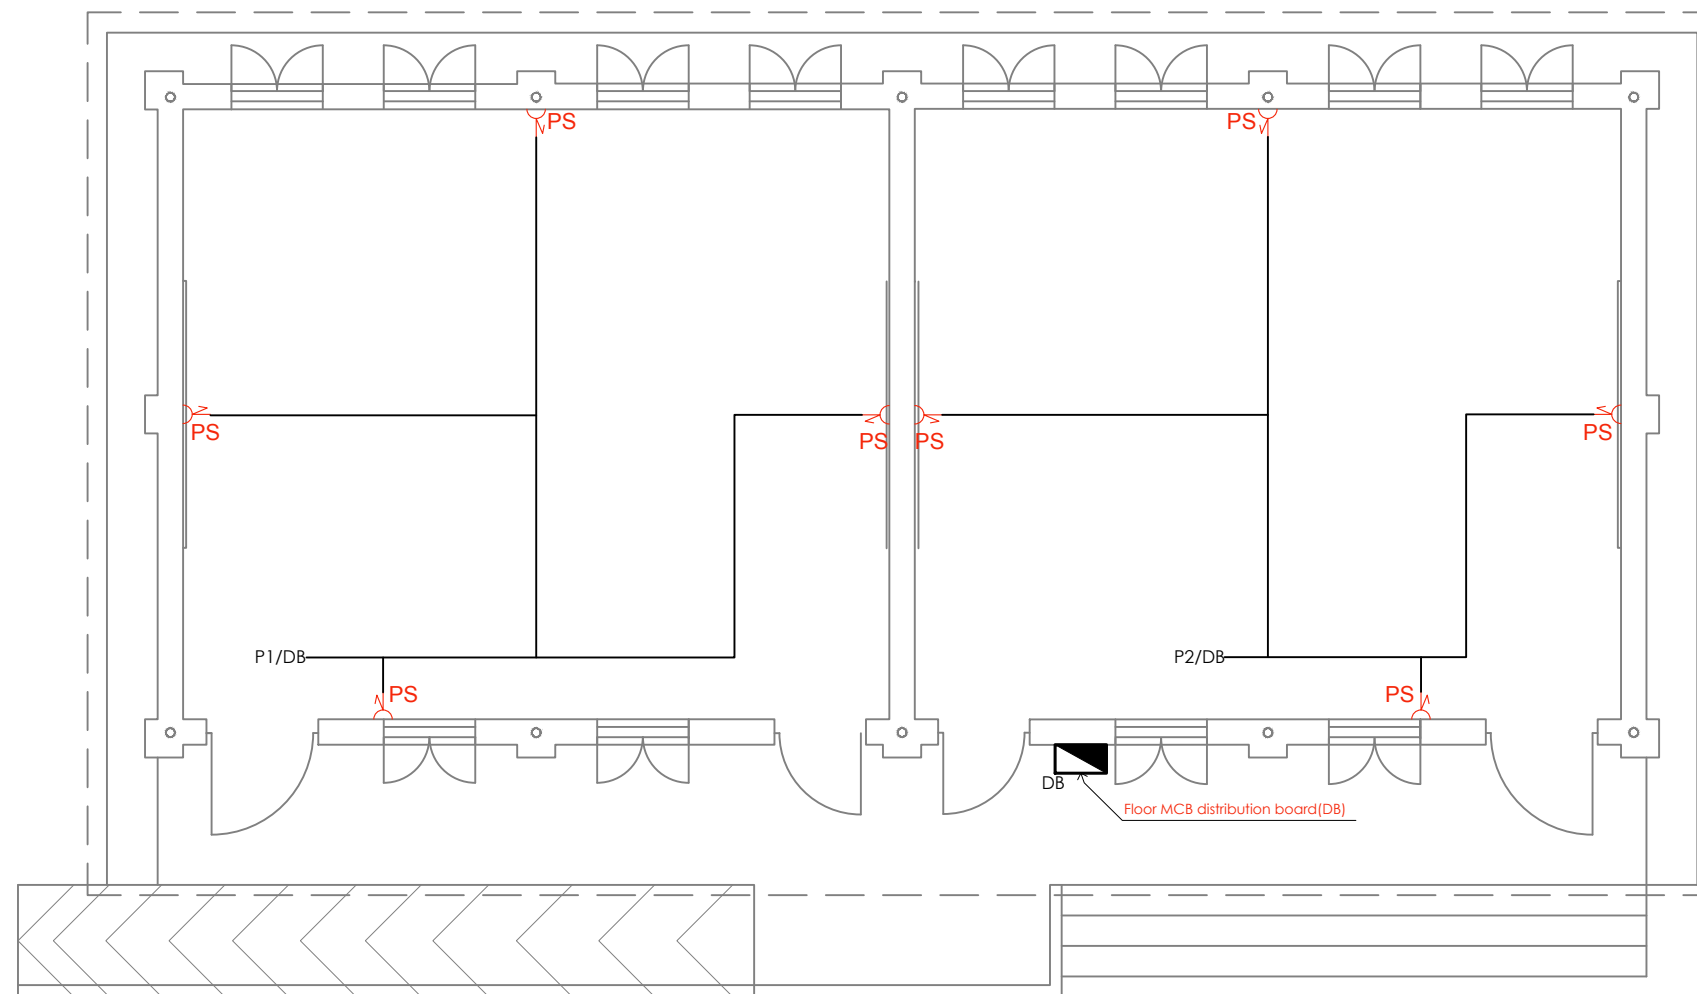

POWER POINT LAYOUT PLAN

LEGEND

S.N.	Particulars	Symbol
1	24 W LED Panel Light	
2	Floor MCB distribution board(DB)	
3	One way modular switch(Multi-gang)	
4	Two way modular switch	
5	6/16A 5 Pin switch socket outlet	
6	Ceiling Fan	
7	9W Square type LED Light	

